



ANY MODIFICATIONS TO THESE PLANS OR REUSE OF THESE PLANS MUST BE APPROVED BY AND SIGNED BY THE ARCHITECT

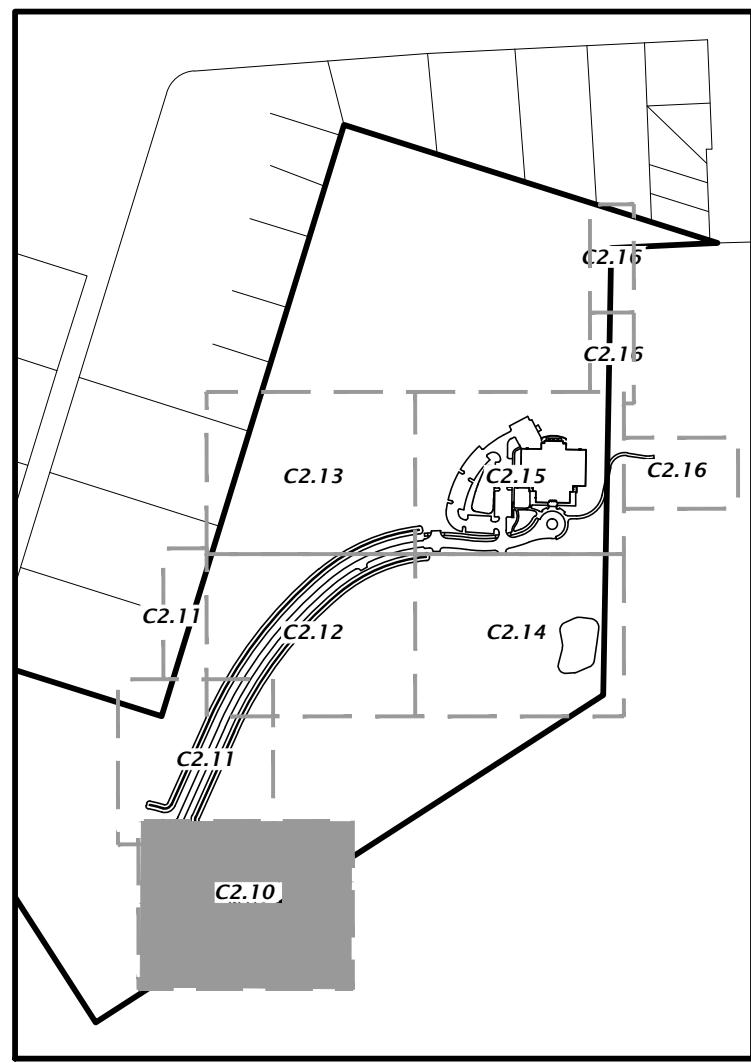

KEY MAP
NTS

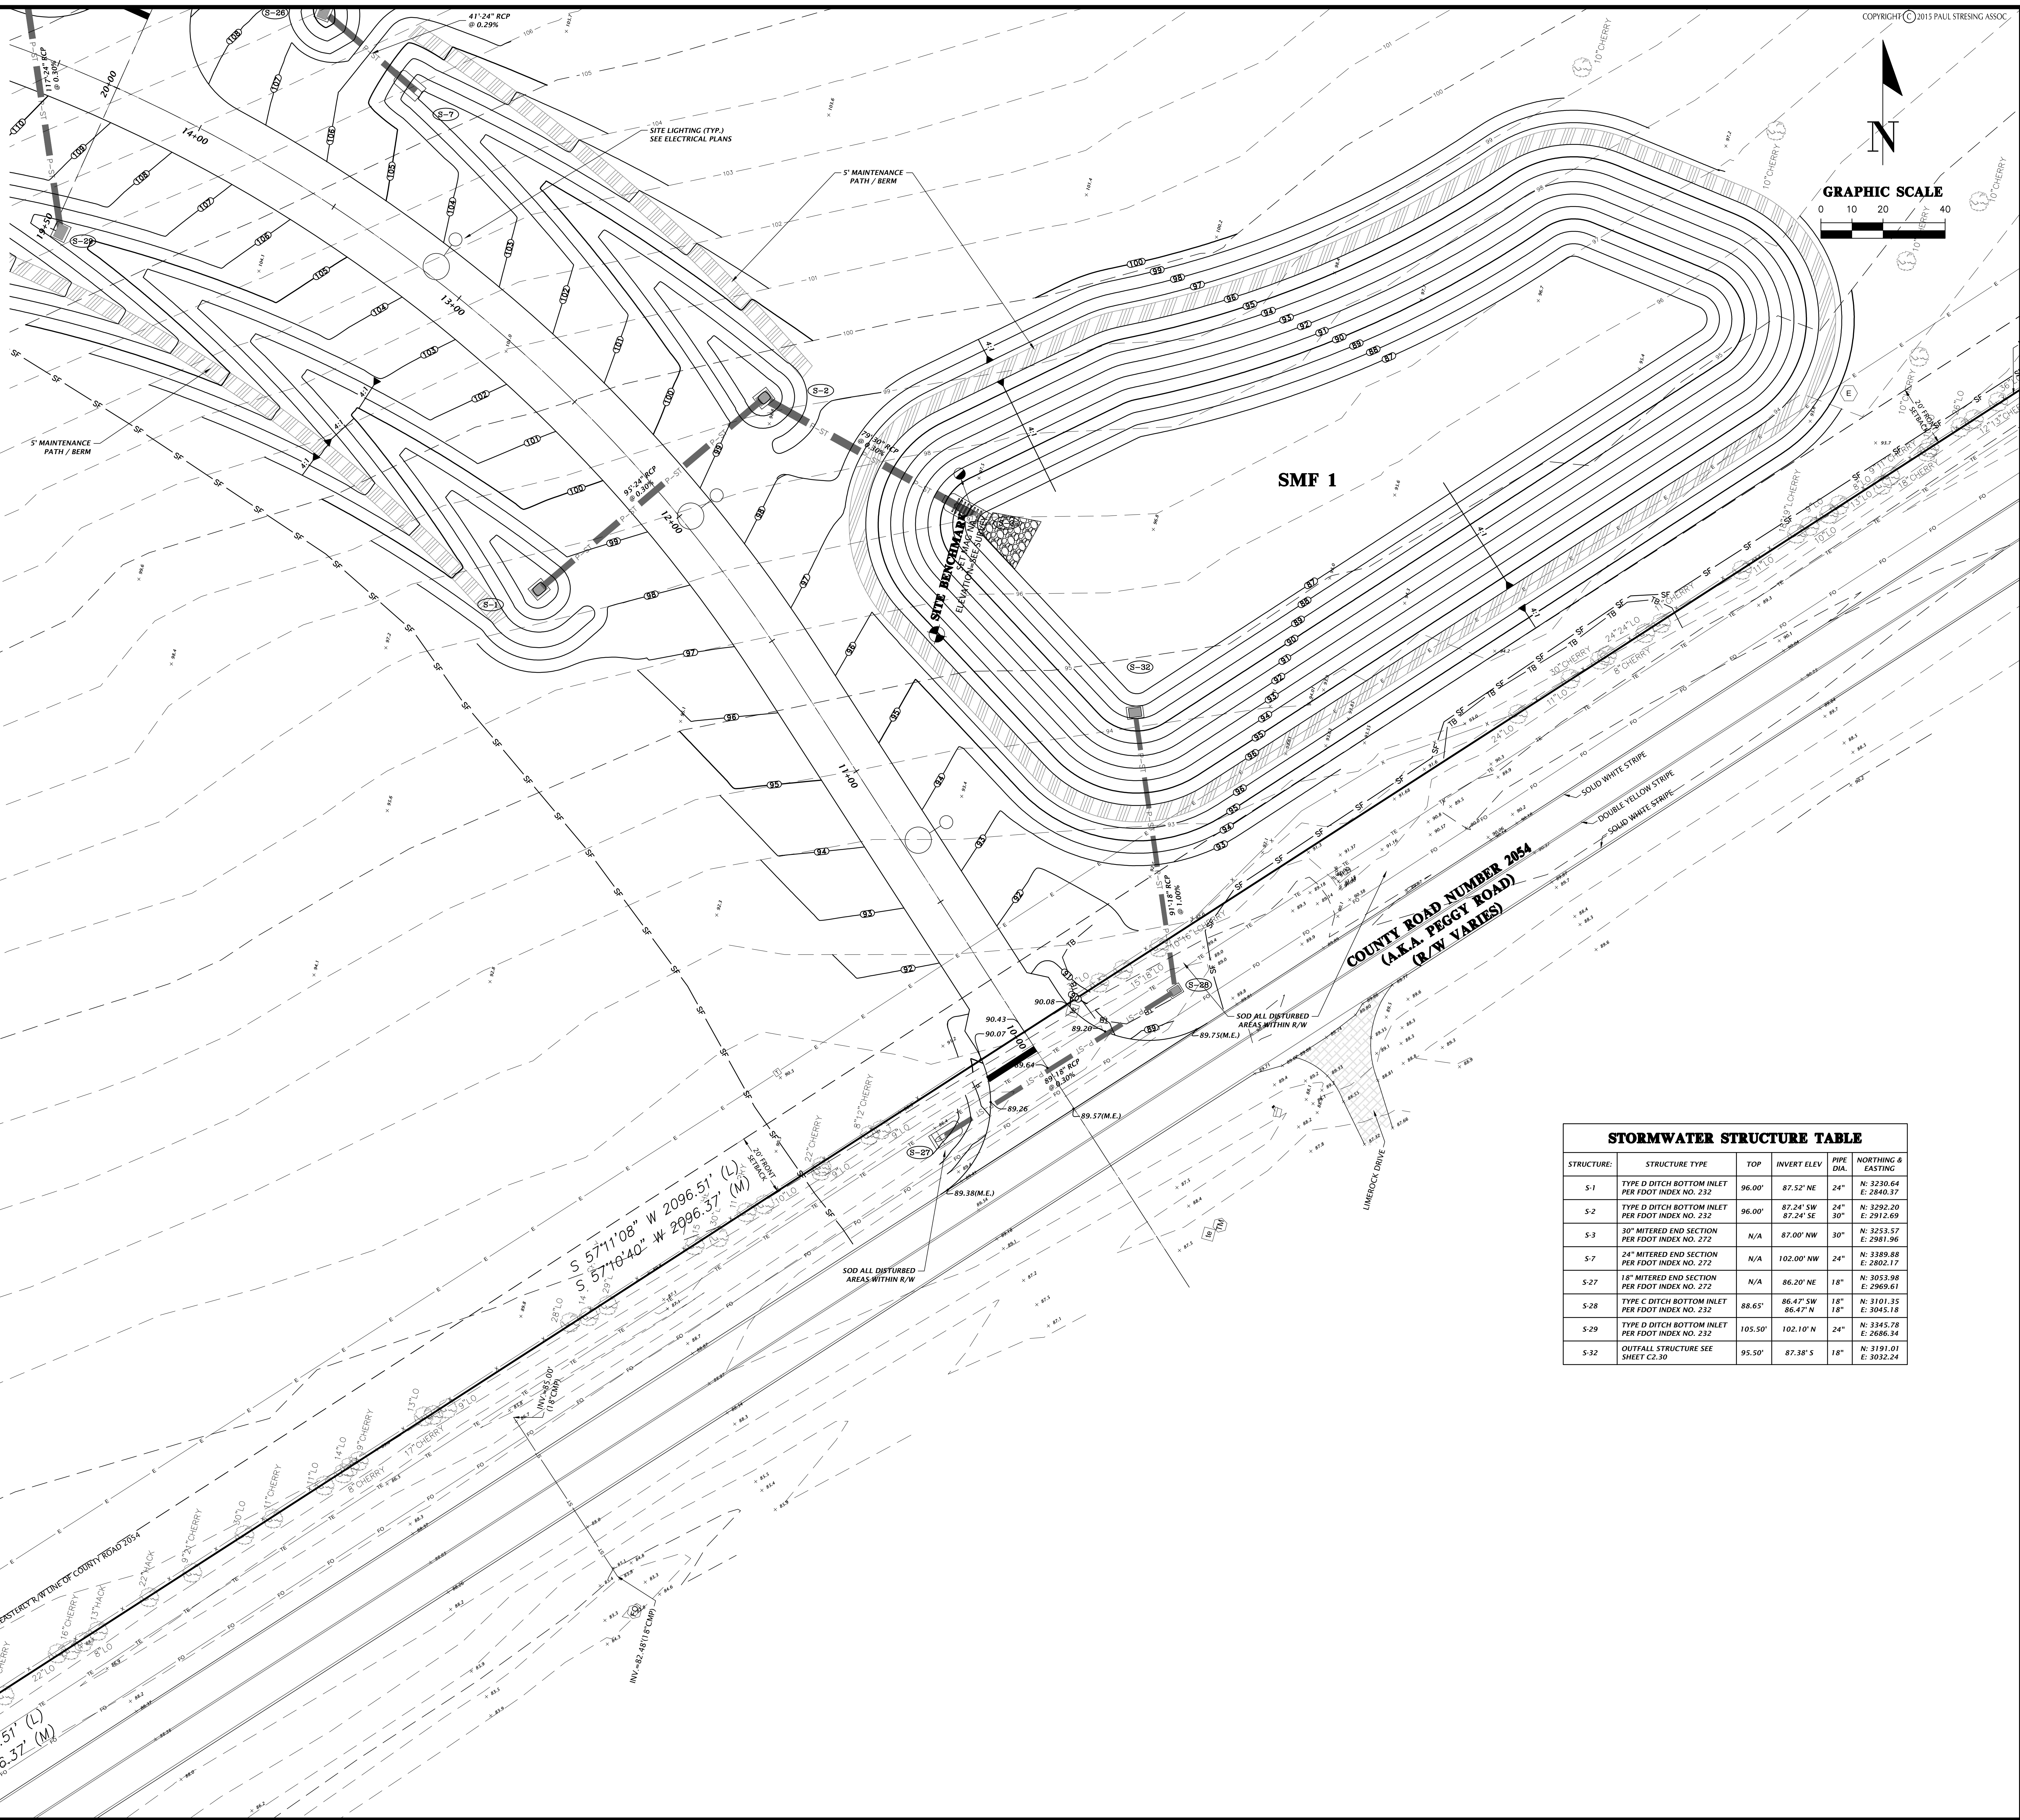

STORMWATER STRUCTURE TABLE					
STRUCTURE:	STRUCTURE TYPE	TOP	INVERT ELEV	PIPE DIA.	NORTHING & EASTING
S-1	TYPE D DITCH BOTTOM INLET PER FDOT INDEX NO. 232	96.00'	87.52' NE	24"	N: 3230.64 E: 2940.37
S-2	TYPE D DITCH BOTTOM INLET PER FDOT INDEX NO. 232	96.00'	87.24' SW 87.24' SE	24"	N: 3292.20 E: 2912.69
S-3	30" MITERED END SECTION PER FDOT INDEX NO. 272	N/A	87.00' NW	30"	N: 3253.57 E: 2981.96
S-7	24" MITERED END SECTION PER FDOT INDEX NO. 272	N/A	102.00' NW	24"	N: 3389.88 E: 2902.17
S-27	18" MITERED END SECTION PER FDOT INDEX NO. 272	N/A	86.20' NE	18"	N: 3053.98 E: 2969.61
S-28	TYPE C DITCH BOTTOM INLET PER FDOT INDEX NO. 232	88.65'	86.47' SW 86.47' N	18"	N: 3101.35 E: 3045.18
S-29	TYPE D DITCH BOTTOM INLET PER FDOT INDEX NO. 232	105.50'	102.10' N	24"	N: 3345.78 E: 2986.34
S-32	OUTFALL STRUCTURE SEE SHEET C2.30	95.50'	87.38' S	18"	N: 3191.01 E: 3032.24

DRAWN BY:
KMA
DATE:
FEBRUARY 23, 2016
PROPOSAL NO.:
15-040

CHW
Professional Consultants

P2B SUBMITTAL
DETAILED GRADING AND DRAINAGE PLAN

CITY OF ALACHUA
LEGACY PARK - PHASE 1
ALACHUA, FLORIDA


REVISIONS
ITEM:
DATE:
JAMES A. FLEGERT

FL PE No. 69147
SHEET NO.
C2.10



15-0451

ANY MODIFICATIONS TO THESE PLANS OR REUSE OF THESE PLANS MUST BE APPROVED BY AND SIGNED BY THE ARCHITECT

PLAT BOOK "F", PAGE "77"

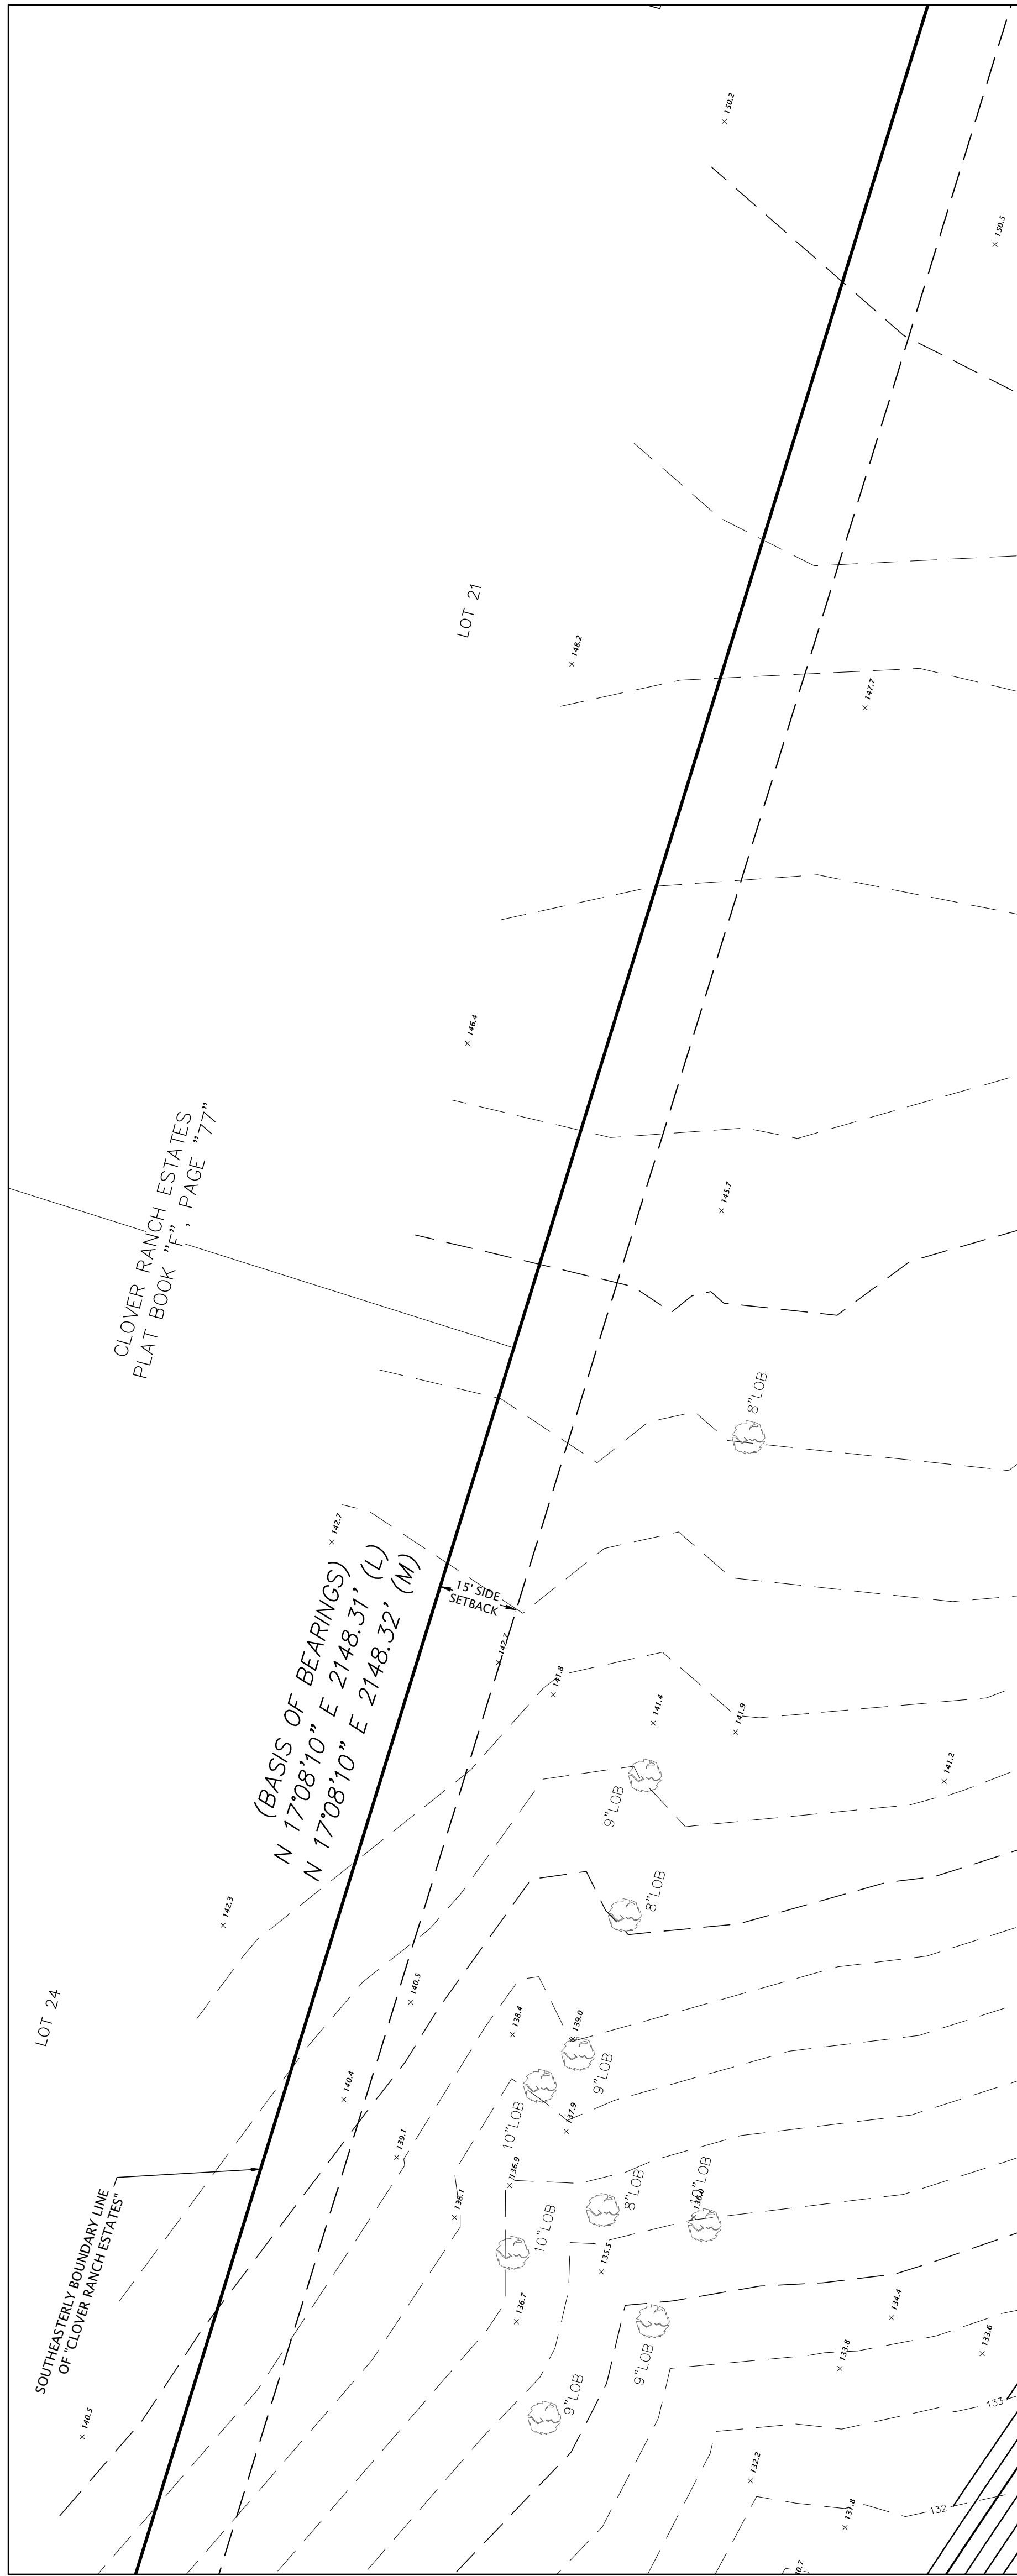

STORMWATER STRUCTURE TABLE					
STRUCTURE:	STRUCTURE TYPE	TOP	INVERT ELEV.	PIPE DIA.	NORTHING & EASTING
S-6	TYPE D DITCH BOTTOM INLET PER FDOT INDEX NO. 232	106.04'	102.45' S	24"	N: 2461.25 E: 2669.42
S-7	24" MITERED END SECTION PER FDOT INDEX NO. 272	N/A	102.00' NW	24"	N: 3389.88 E: 2802.17
S-26	TYPE D DITCH BOTTOM INLET PER FDOT INDEX NO. 232	105.37'	102.12' SE	24"	N: 3416.68 E: 2771.04
S-29	TYPE D DITCH BOTTOM INLET PER FDOT INDEX NO. 232	105.50'	102.10' N	24"	N: 3345.78 E: 2686.34

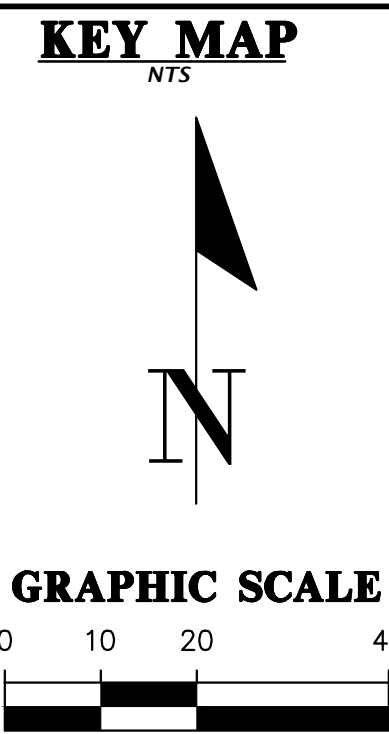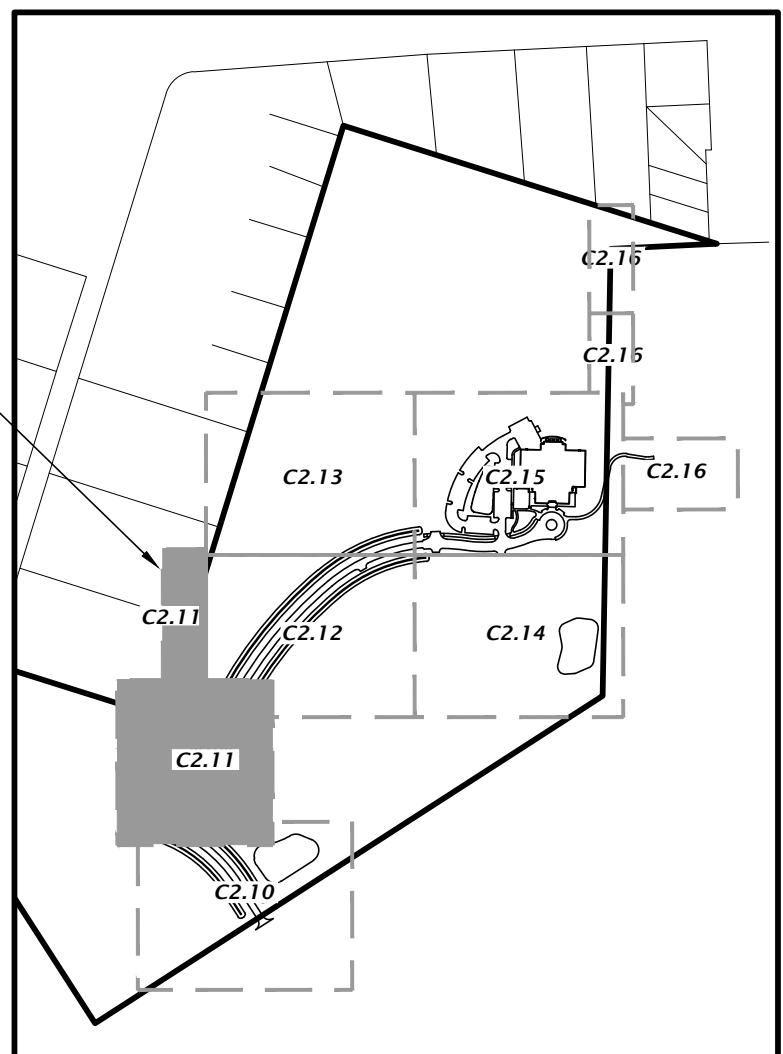

N

0 10 20 40

S 72°27'14" E 1320.45' (L)
S 72°27'41" E 1320.42' (M)

15' SIDE SETBACK

15' SIDE SETBACK

SE CORNER OF LOT 24

15' SIDE SETBACK

15' SIDE SETBACK


15' SIDE SETBACK

15' SIDE SETBACK

15' SIDE SETBACK

15' SIDE SETBACK

15' SIDE SETBACK

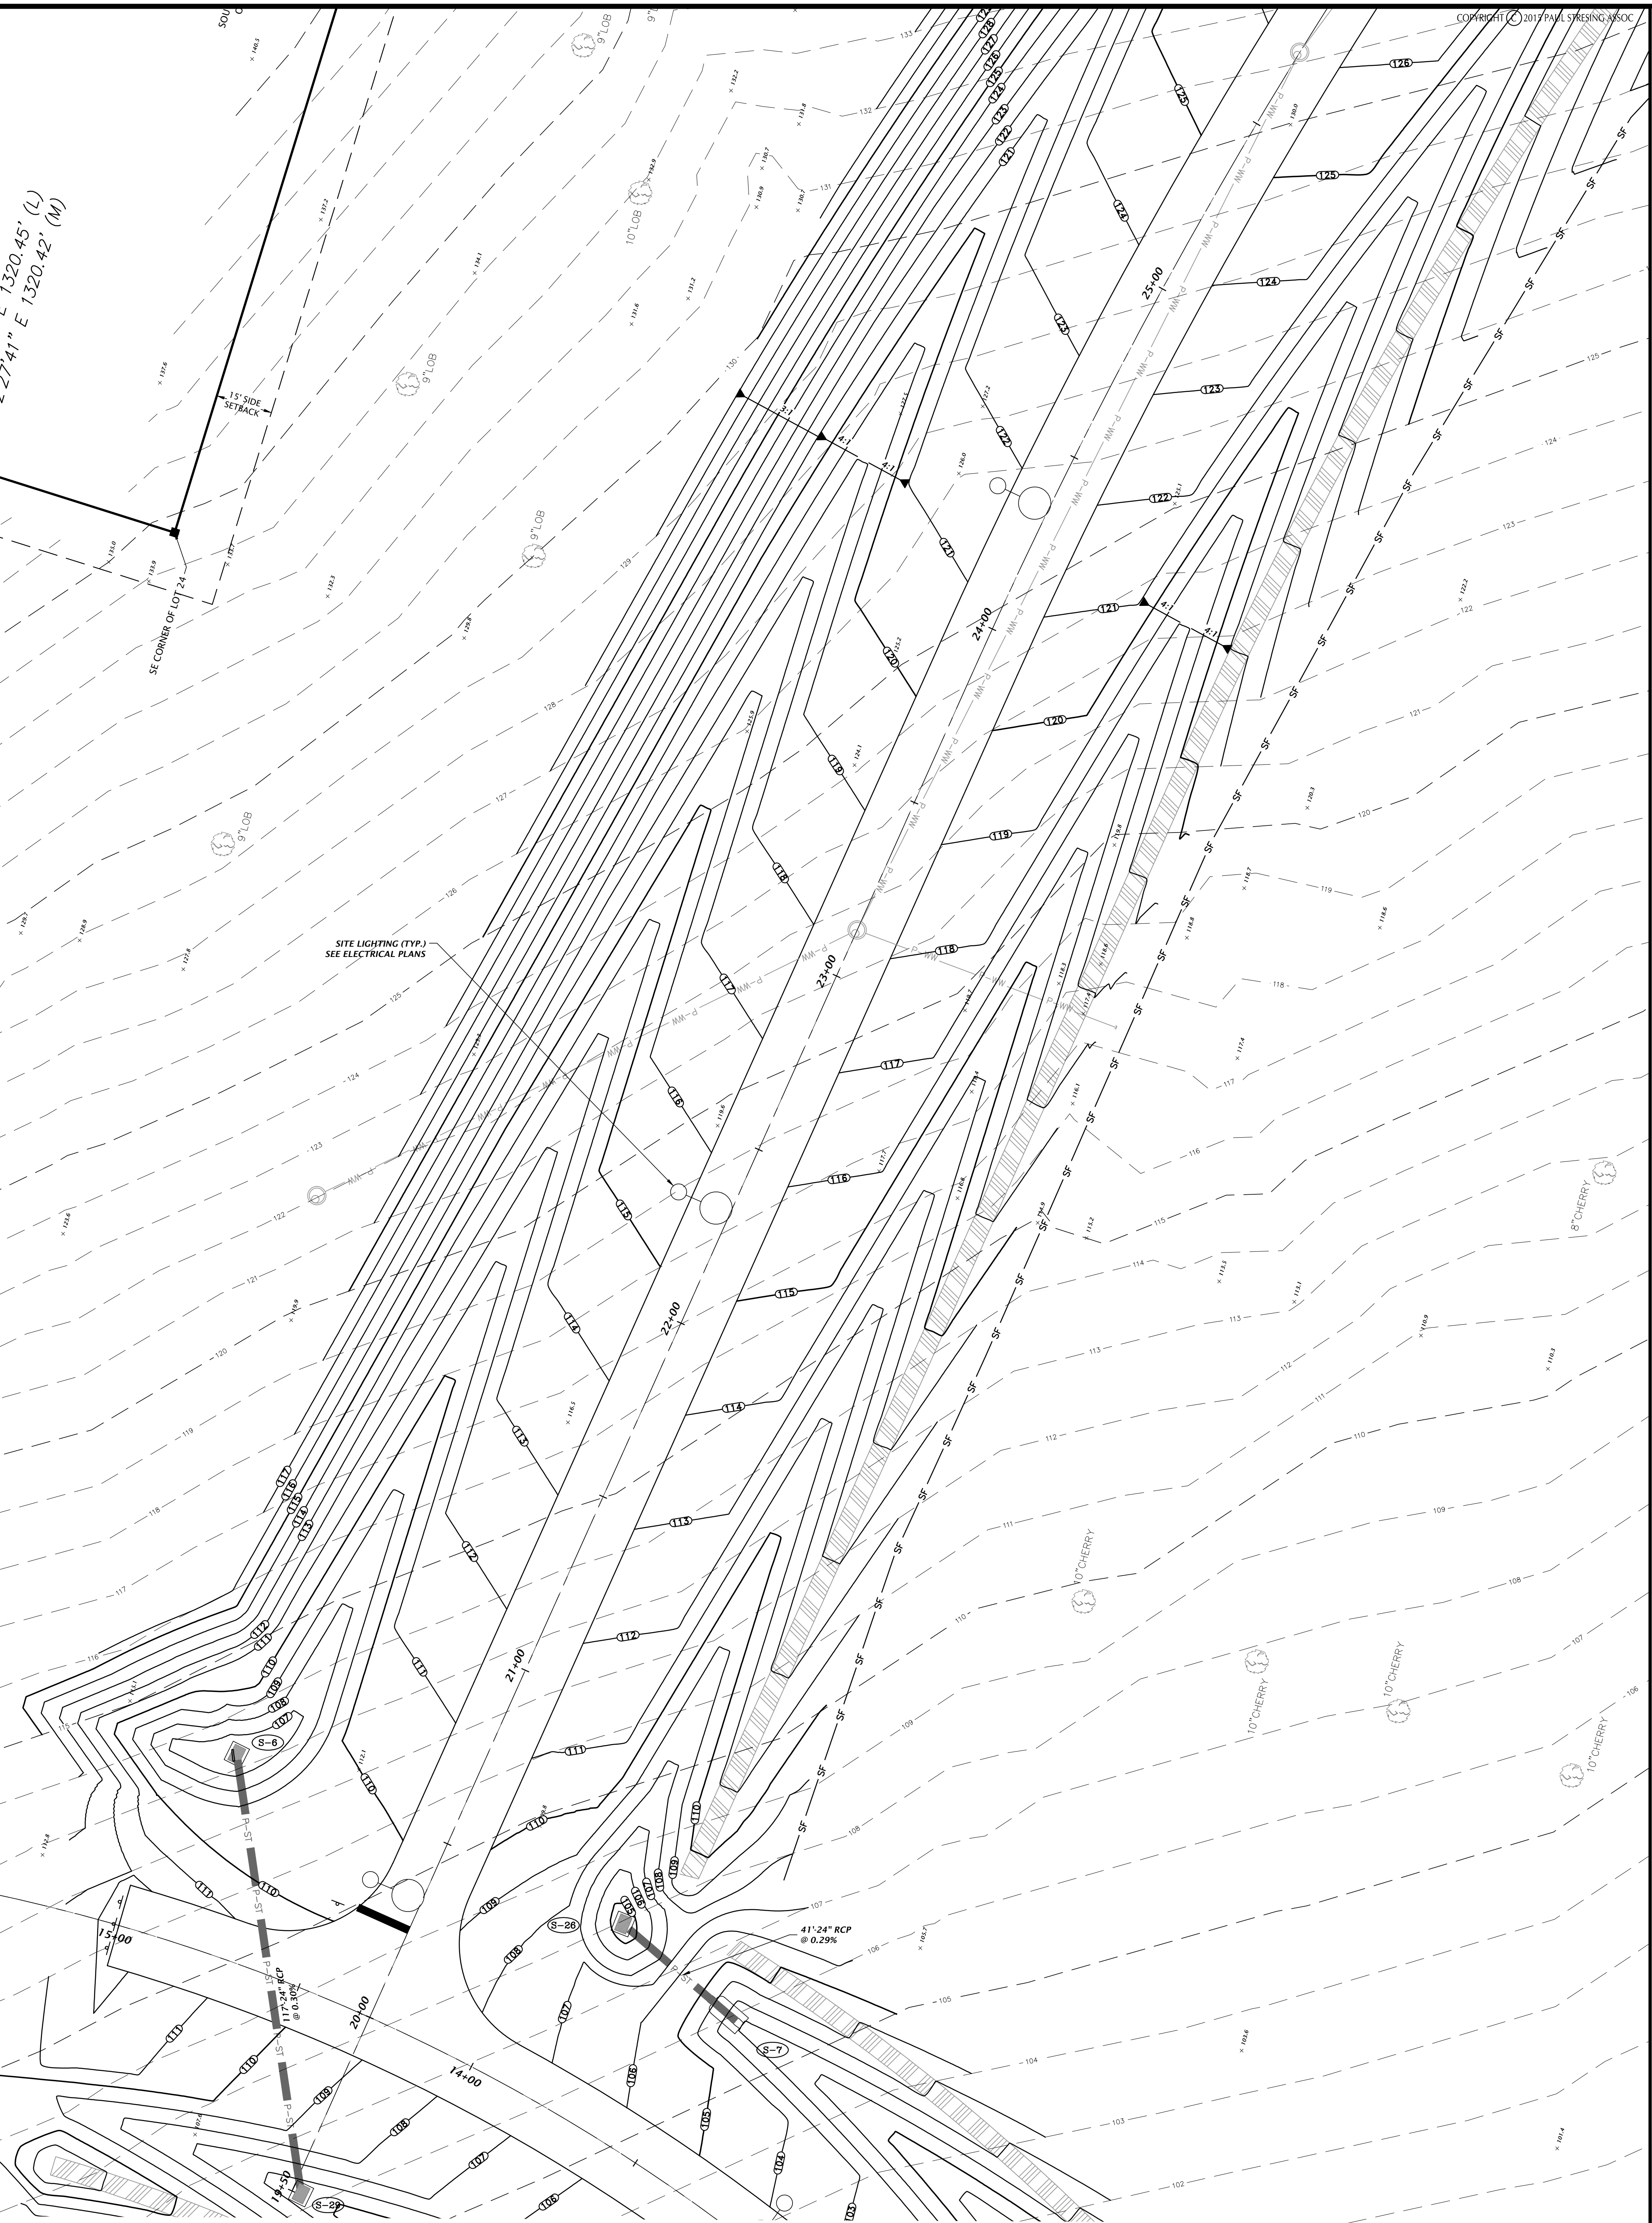

REVISIONS
TEXT
DATE:
JAMES A. FLEIGHT

FL/PE No. 69147
SHEET NO.
C2.11

CHW
Professional Consultants

P2B SUBMITTAL
DETAILED GRADING AND DRAINAGE PLAN


CITY OF ALACHUA
LEGACY PARK - PHASE 1
ALACHUA, FLORIDA

101 NE 14th Avenue
Ocala, Florida 34703
(889) 414-4827 / 1889 351-2478
www.chw-inc.com
est. 1988 FLORIDA
CA-5975 15440


DRAWN BY:
MFA
DATE:
FEBRUARY 23, 2016
PROPOSAL NO.:
15440

ANY MODIFICATIONS TO THESE PLANS OR REUSE OF THESE PLANS MUST BE APPROVED BY AND SIGNED BY THE ARCHITECT

Plot Number: 202 Date: Feb. 24, 2015 4:23pm File Name: L:\2015\15-0451\LegacyPark\Drawings\DWG\15-0451_C2.13_P202.dwg

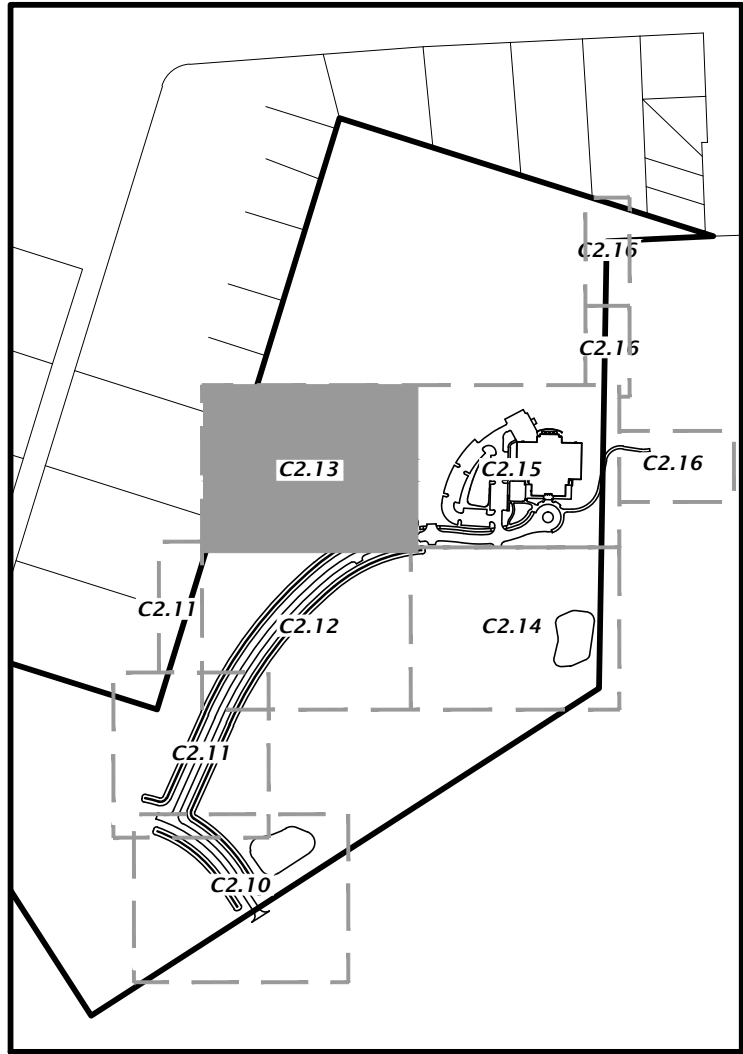

KEY MAP
NTS

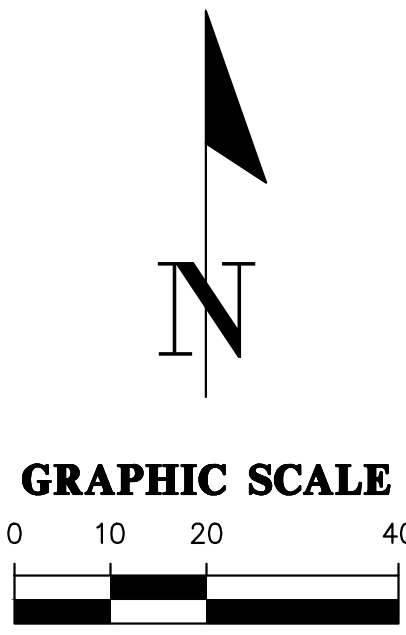

LOT 20

N 17°08'10" E 2148.31' (L)
N 17°08'10" E 2148.32' (M)
(BASIS OF BEARINGS)

SITE BENCHMARK
SURVEY
ELEVATION SEE SURVEY

PICNIC PAVILION
SEE LANDSCAPE PLANS


SITE LIGHTING (TYP.)
SEE ELECTRICAL PLANS

PICNIC PAVILION
SEE LANDSCAPE PLANS

COPYRIGHT © 2015 PAUL STRESSING ASSOC.

CITY OF ALACHUA LEGACY PARK - PHASE 1 ALACHUA, FLORIDA	P2B SUBMITTAL DETAILED GRADING AND DRAINAGE PLAN	CHW Professional Consultants	REVISIONS TEXT	DATE	DESIGNED BY JAMES A. FLEGERT
			FL PE No. 69147 SHEET NO. C2.13	DRAWN BY: MKA 101 NE 14th Avenue Ocala, Florida 34703 (882) 414-4827 / 882-351-2478 www.chw-inc.com est. 1988 FLORIDA 04-5975	

Tech: kurtm Plot Date: Feb 24, 2016 4:22pm Filename: L:\2015\15-0451\engineering\DWGs\production files\15-0451_C2.10_DGP.dwg

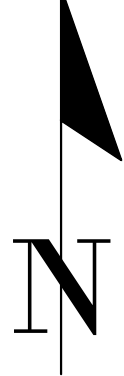

KEY MAP
NTS

STORMWATER STRUCTURE TABLE					
STRUCTURE:	STRUCTURE TYPE	TOP	INVERT ELEV	PIPE DIA.	NORTHING & EASTING
S-10	TYPE D 24" BENT BOTTOM INLET PER FDOT INDEX NO. 212	122.59'	116.00' N	18"	N+ 4335.32 E+ 3569.44
S-19	24" MITERED END SECTION PER FDOT INDEX NO. 272	N/A	88.00' N	24"	N+ 4109.65 E+ 4099.89
S-19	STORM MANHOLE PER FDOT INDEX NO. 200 AND NO. 201	107.03'	94.11' S 94.11' NW	24"	N+ 3307.55 E+ 4052.05
S-23	18" MITERED END SECTION PER FDOT INDEX NO. 272	N/A	83.00' NW	18"	N+ 3891.08 E+ 4141.32
S-24	OUTFALL STRUCTURE SEE SHEET C2.32	91.50'	87.75' SE	18"	N+ 3924.13 E+ 4104.43

- SITE LIGHTING (TYP.)
SEE ELECTRICAL PLANS

SMF 3

COPYRIGHT (C) 2015 PAUL STRESING ASSOC

101 NE 1st Avenue Ocala, Florida 34470 (352) 414-4821 / (352) 331-2478 www.chw-inc.com	DRAWN BY: KEM
	DATE: FEBRUARY 25, 2016
	PROPOSAL NO: 15-640



CHN
Professional Consultants

PZB SUBMITTAL	
DETAILED GRADING AND DRAINAGE PLAN	

CITY OF ALACHUA
LEGACY PARK - PHASE 1
ALACHUA, FLORIDA


REVISIONS	
DATE:	ITEM:

JAMES A. FLEGERT

FL PE No. 69147
SHEET NO.
C2.14


15-0451

ANY MODIFICATIONS TO THESE PLANS OR REUSE OF THESE PLANS MUST BE APPROVED BY AND SIGNED BY THE ARCHITECT

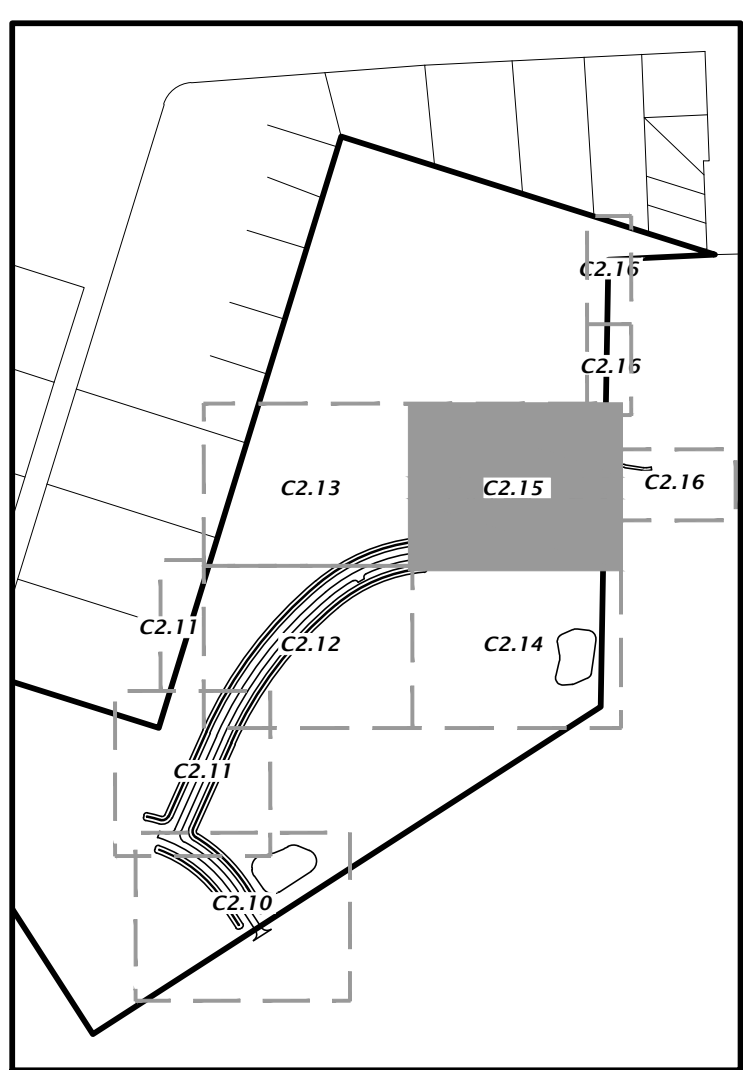

KEY MAP

STORMWATER STRUCTURE TABLE						
STRUCTURE	STRUCTURE TYPE	TOP	INVERT ELEV.	PIPE DIA.	NORTHING & EASTING	
S-8	18" MITERED END SECTION PER FDOT INDEX NO. 272	N/A	111.00' SW	18"	N: 4510.36	E: 3747.36
S-9	TYPE D DITCH BOTTOM INLET PER FDOT INDEX NO. 232	122.68'	115.04' NE	18"	N: 4429.95	E: 3562.17
S-10	TYPE D DITCH BOTTOM INLET PER FDOT INDEX NO. 232	122.59'	116.00' N	18"	N: 4335.32	E: 3569.44
S-11	15" MITERED END SECTION PER FDOT INDEX NO. 272	N/A	111.00' E	15"	N: 4591.33	E: 3792.55
S-12	TYPE D DITCH BOTTOM INLET PER FDOT INDEX NO. 232	114.96'	111.48' W	15"	N: 4590.16	E: 3840.36
S-13	TYPE 6 CURB INLET PER FDOT INDEX NO. 211	112.26'	106.14' SE	24"	N: 4388.90	E: 3941.40
S-14	TYPE 6 CURB INLET PER FDOT INDEX NO. 211	112.24'	106.25' SE	24"	N: 4423.40	E: 3906.34
S-15	OUTFALL STRUCTURE SEE SHEET C2.31	113.50'	108.63' E	15"	N: 4514.59	E: 3752.78
S-16	TYPE C DITCH BOTTOM INLET WITH STEEL GATE PER FDOT INDEX NO. 232	111.72'	107.80' W	15"	N: 4521.24	E: 3907.43
S-17	STORM MANHOLE PER FDOT INDEX NO. 200 AND NO. 201	113.14'	108.34' S	18"	N: 4745.01	E: 3883.35
S-18	TYPE D DITCH BOTTOM INLET PER FDOT INDEX NO. 232	111.97'	108.50' SW	18"	N: 4785.33	E: 3915.90
S-25	STORM MANHOLE PER FDOT INDEX NO. 200 AND NO. 201	116.31'	107.64' N	18"	N: 4510.60	E: 3880.20

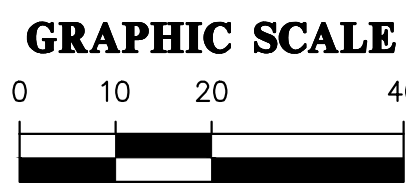

SMT 2

NEW BUILDING

FRE=114.00


CITY OF ALACHUA
LEGACY PARK - PHASE 1
ALACHUA, FLORIDA

REVISIONS
DATE: JAMES A. FLEIGHT

PLP No. 69147
SHEET NO.
C2.15

150451

Tech: kurtm Plot Date: Feb 24, 2016 4:22pm Filename: L:\2015\15-0451\engineering\DWGs\production files\15-0451_C2.10_DGP.dwg

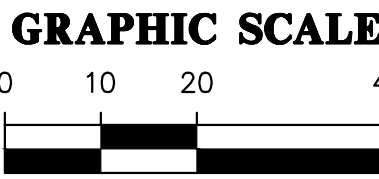


CITY OF ALACHUA
LEGACY PARK - PHASE 1
ALACHUA, FLORIDA

FL PE No. 69147
SHEET NO.
C2.16






ANY MODIFICATIONS TO THESE PLANS OR REUSE OF THESE PLANS MUST BE APPROVED BY AND SIGNED BY THE ARCHITECT

Drawn: J. Flegert, P.E. Date: 2/24/2016 4:23pm. Plotted: J. Flegert, P.E. Date: 2/24/2016 4:23pm. Filename: L:\2015\15-0401\LegacyPark\Drawings\DWG\15-0401_C2.30.dwg

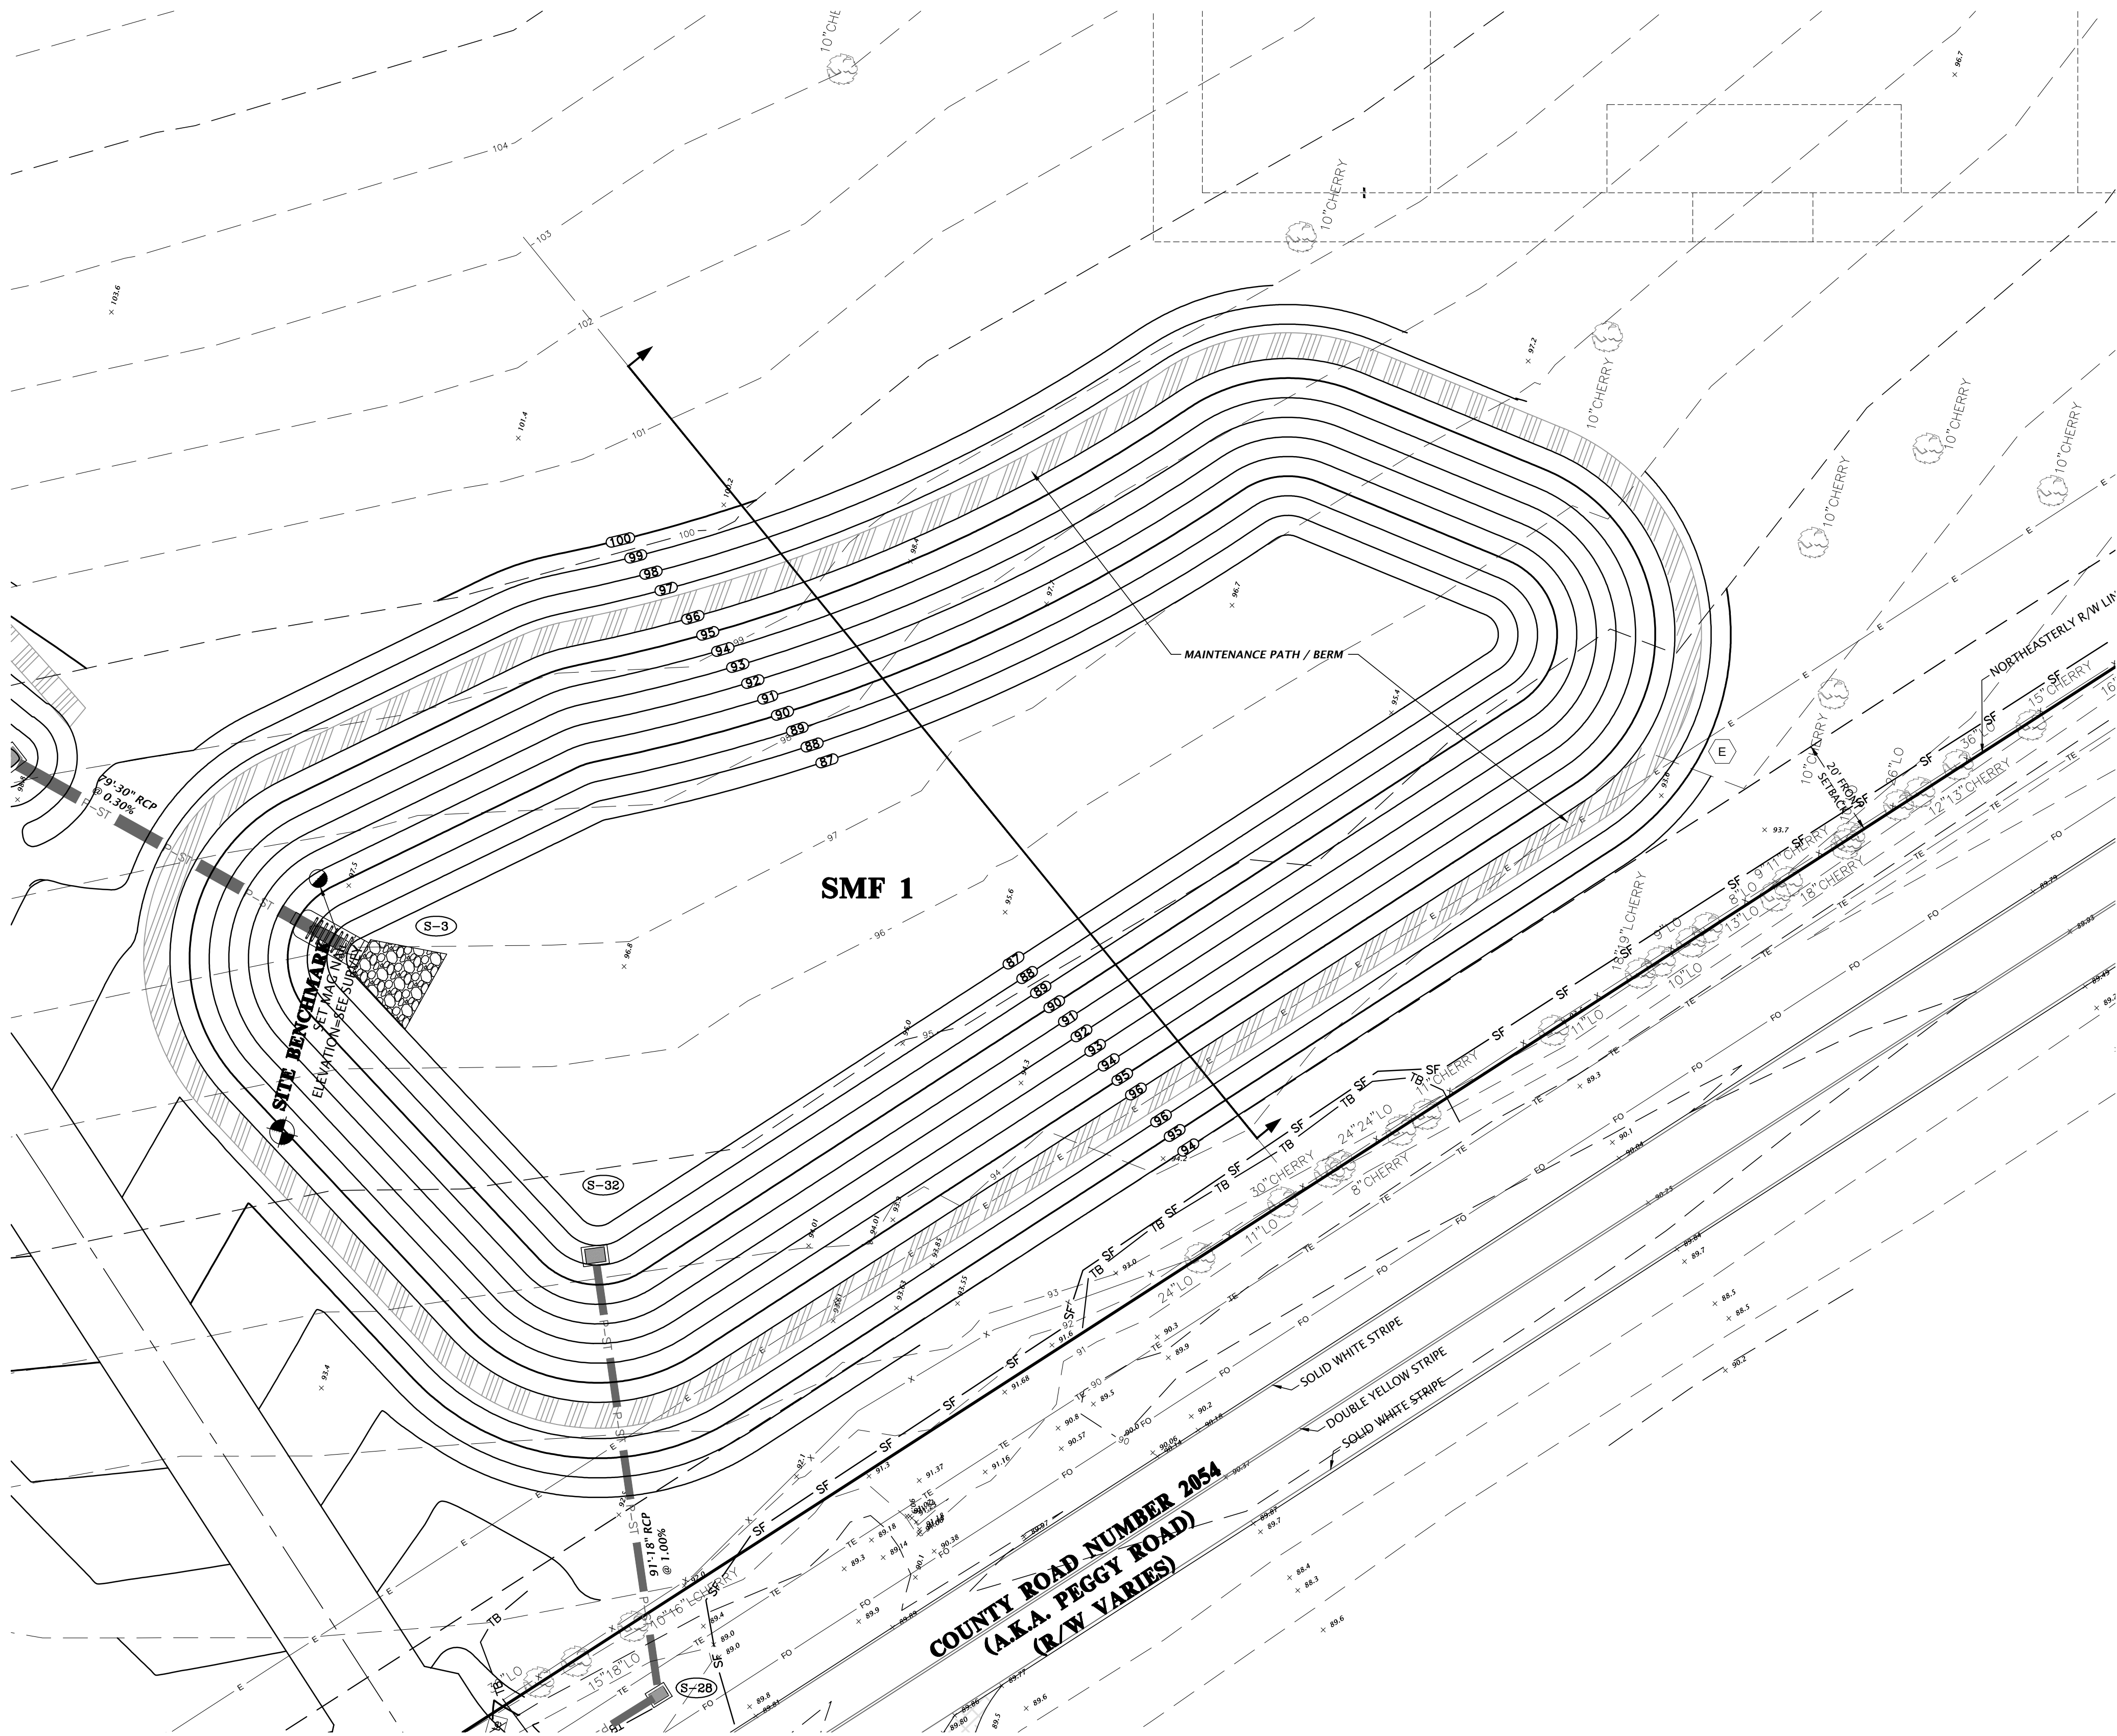

STORMWATER STRUCTURE TABLE					
STRUCTURE:	STRUCTURE TYPE	TOP	INVERT ELEV	PIPE DIA.	NORTHING & EASTING
S-3	30" MITERED END SECTION PER FDOT INDEX NO. 232	N/A	87.00' NW	30"	N: 3253.57 E: 2981.06
S-28	TYPE C DITCH BOTTOM INLET PER FDOT INDEX NO. 232	88.65'	86.47' SW 86.47' N	18"	N: 3101.35 E: 3045.18
S-32	OUTFALL STRUCTURE SEE SHEET C2.30	95.50'	87.38' S	18"	N: 3191.01 E: 3032.24

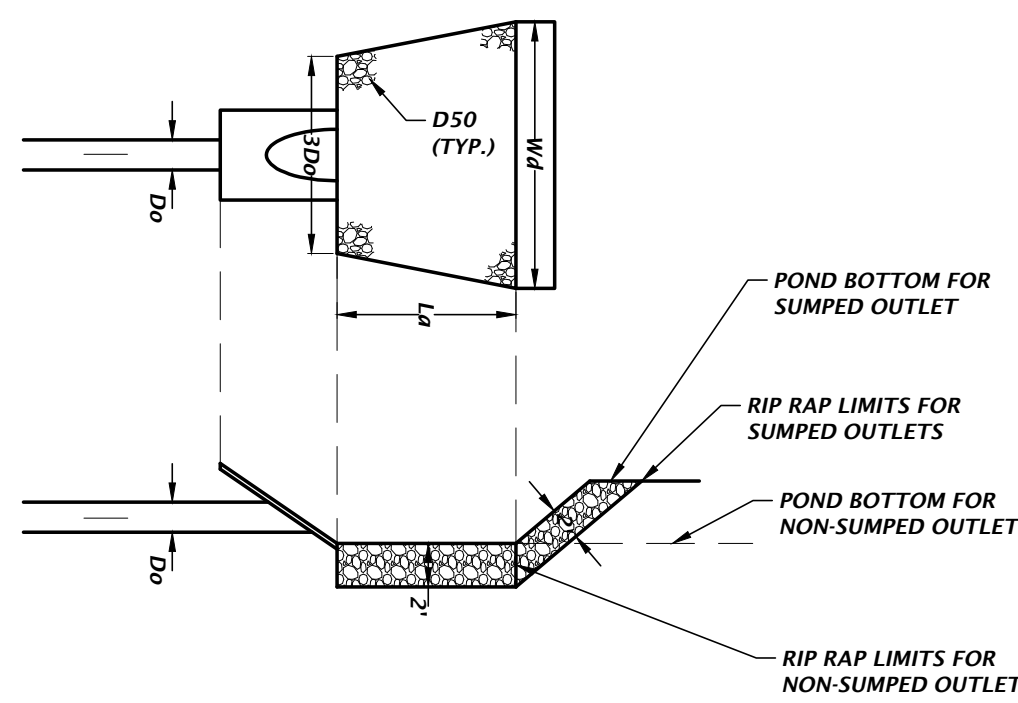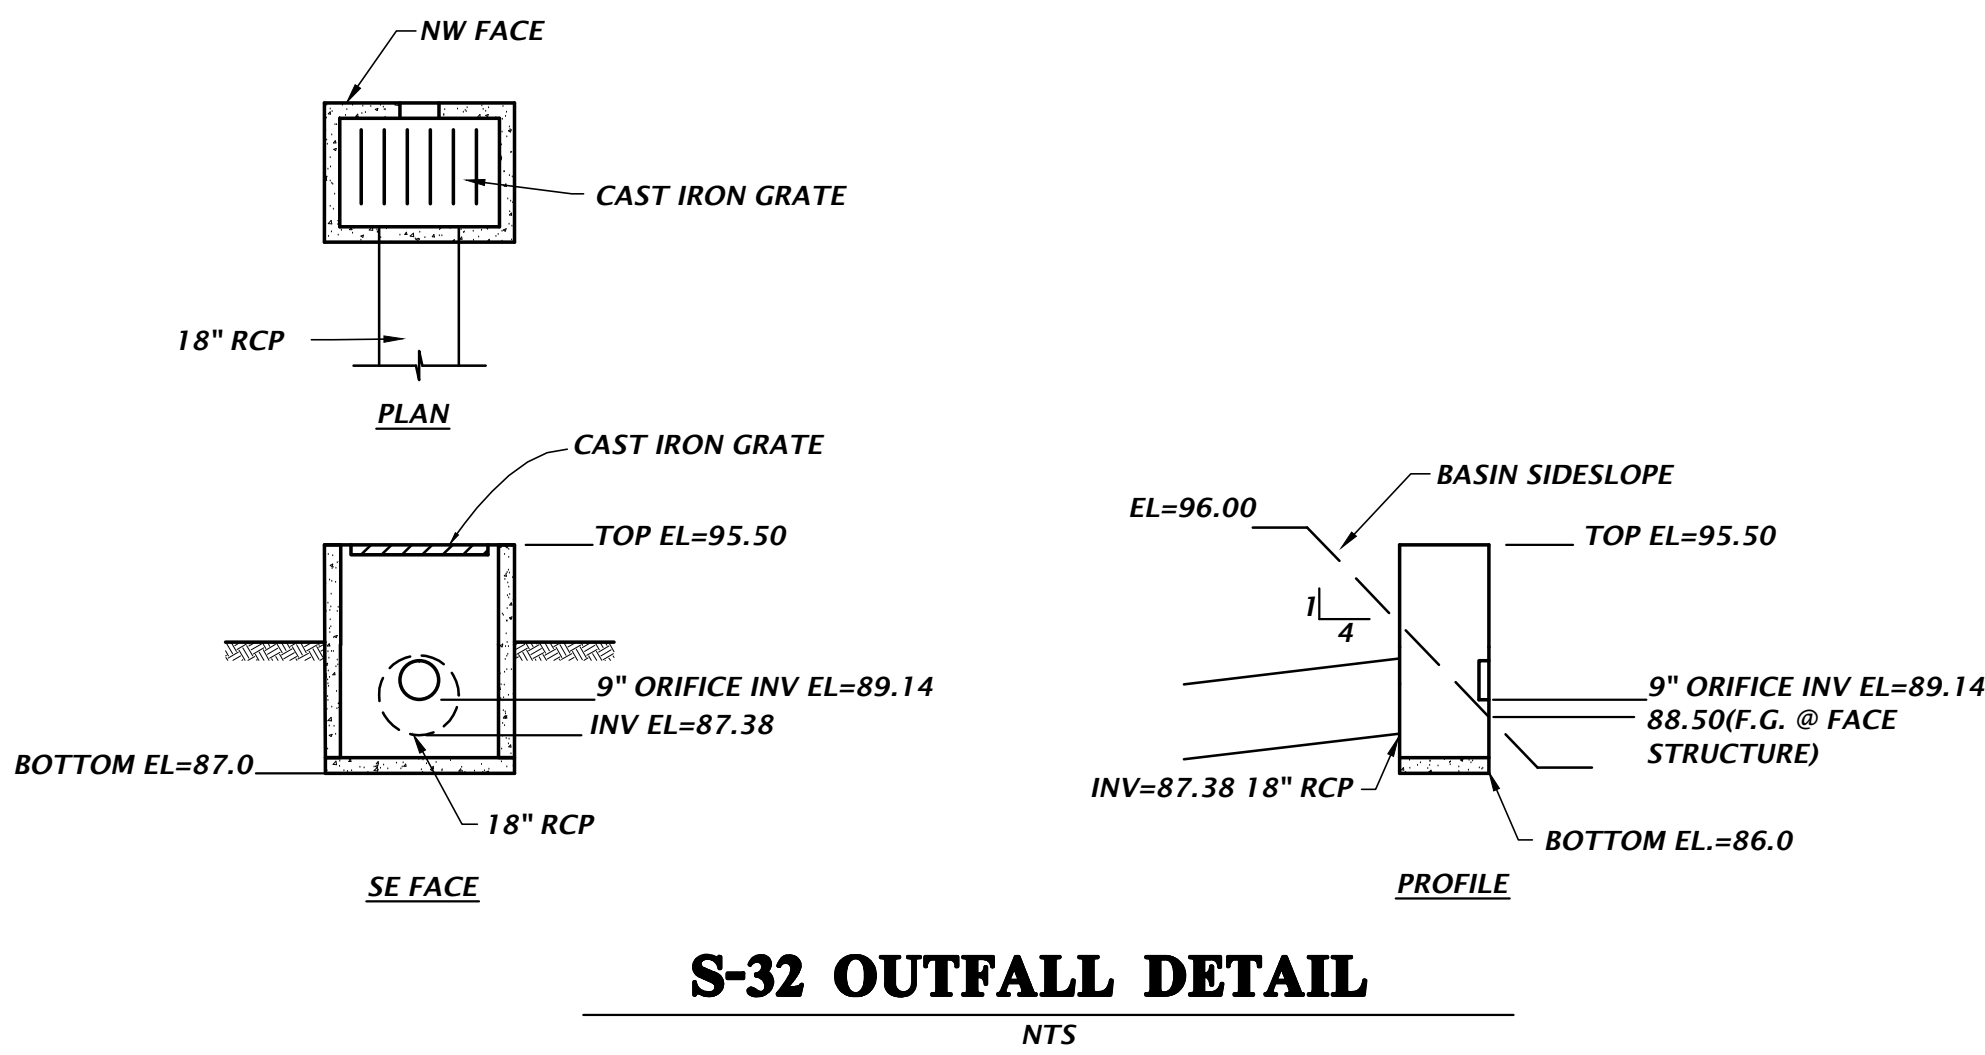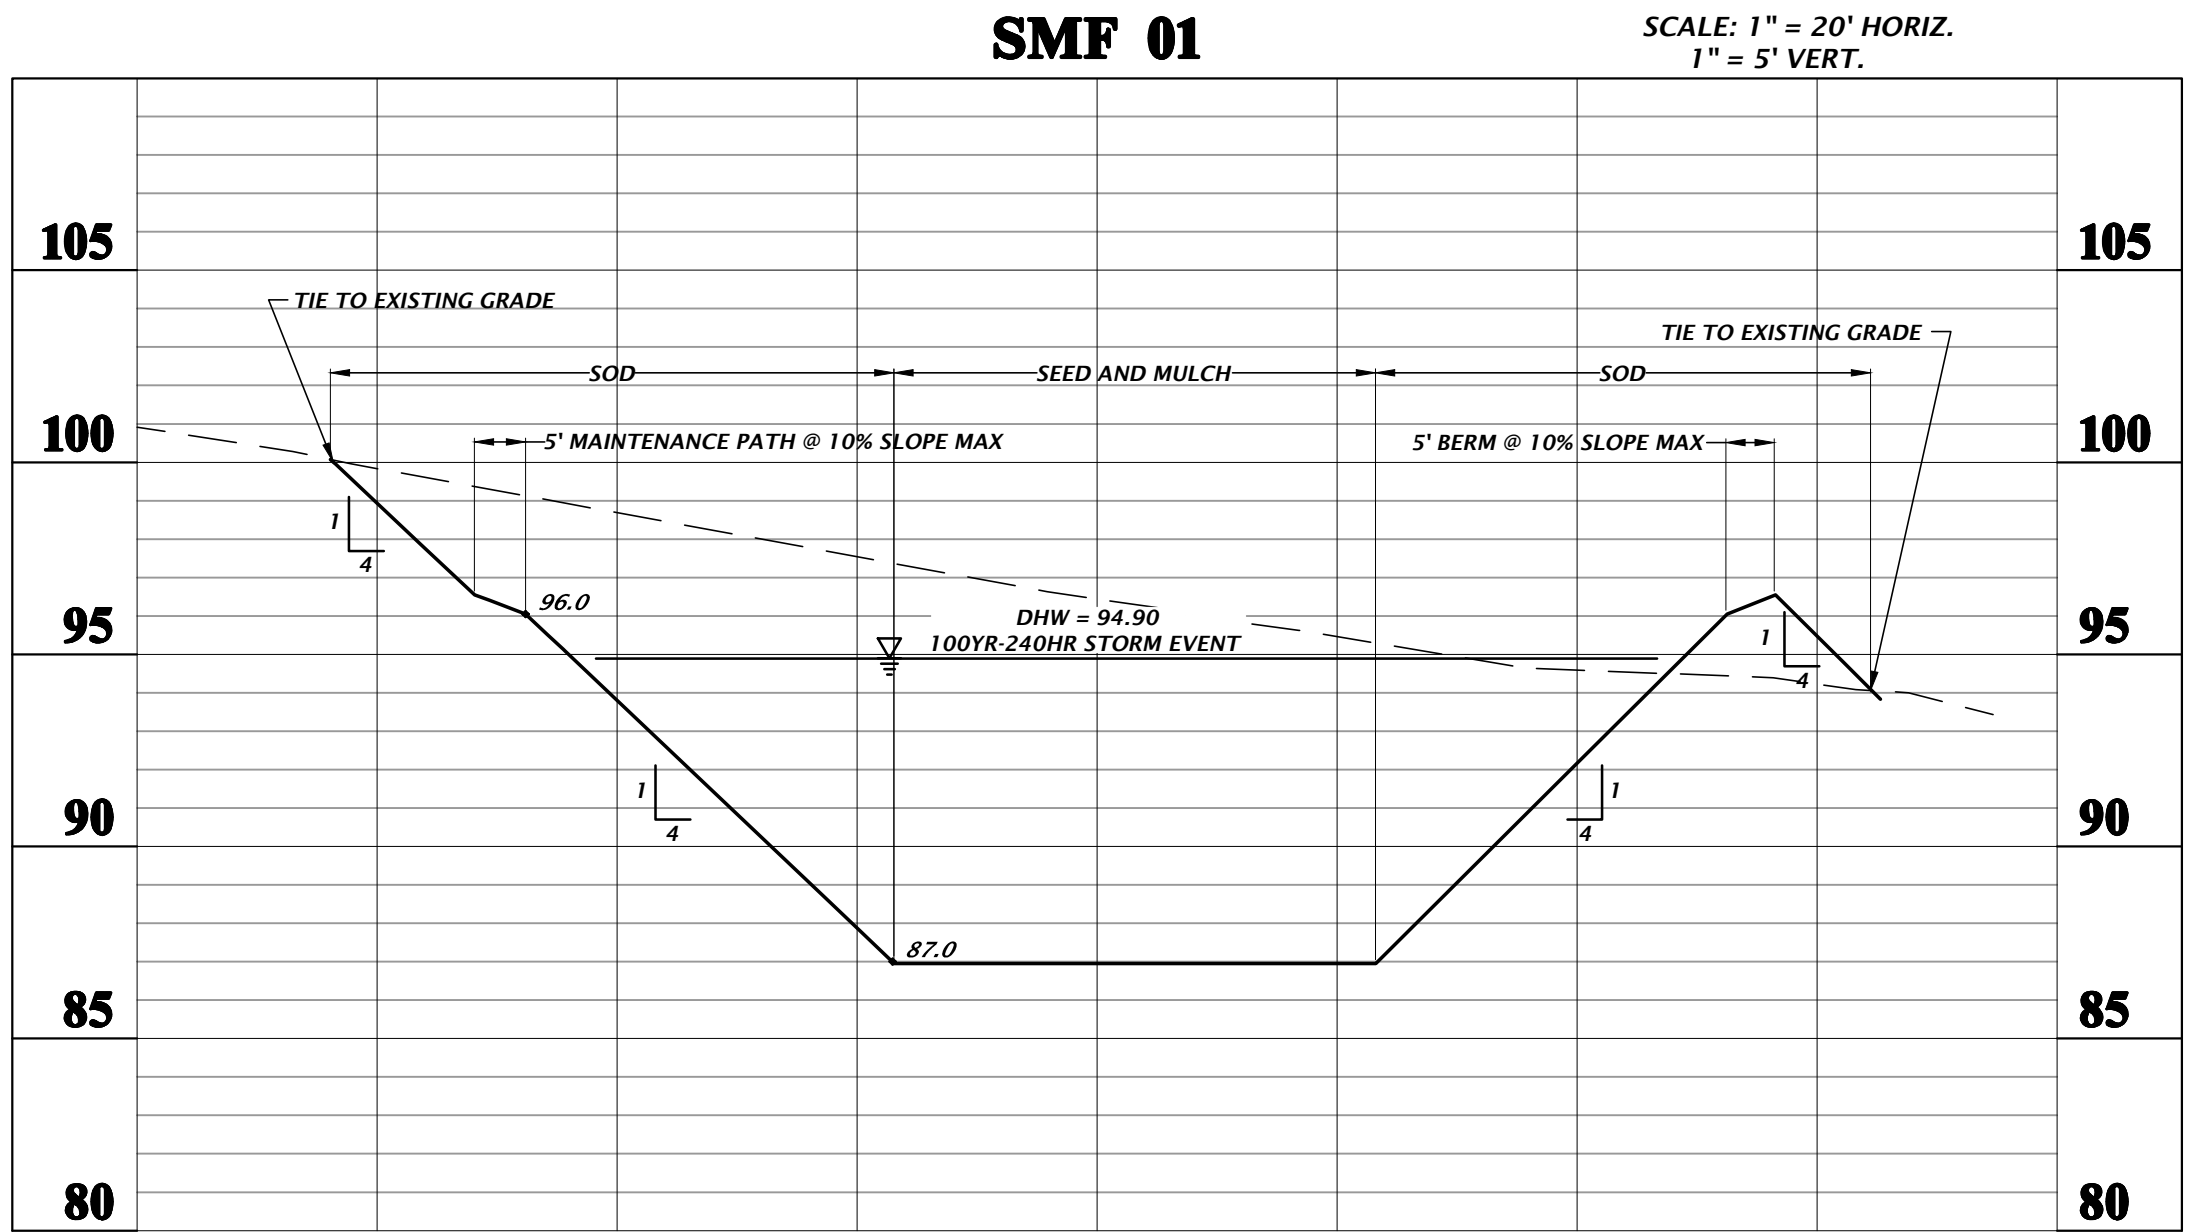

STRUCTURE ID	PIPE DIAMETER D _o (ft)	RIP RAP SPREAD AT PIPE OUTLET S ₁ (ft)	RIP RAP SPREAD AT END OF APRON W ₂ (ft)	LENGTH OF APRON L _a (ft)	MEDIAN RIP RAP SIZE D ₅₀ (ft)
S-3	2.5	7.5	17.5	15	0.5

DRAWN BY: J. Flegert, P.E.
DATE: FEBRUARY 23, 2016
PROJECT NO.: 15-0401
SHEET NO.: C2.30


CHW
Professional Consultants
PZB SUBMITTAL
STORMWATER MANAGEMENT FACILITY 1

CITY OF ALACHUA
LEGACY PARK - PHASE 1
ALACHUA, FLORIDA

REVISIONS
DATE: _____
JAMES A. FLEGERT

FL PE No. 69147
SHEET NO.
C2.30

15-0401

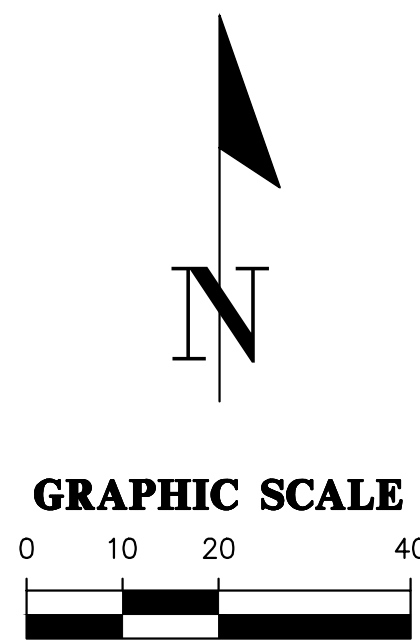

RIP-RAP APRON DETAIL

