



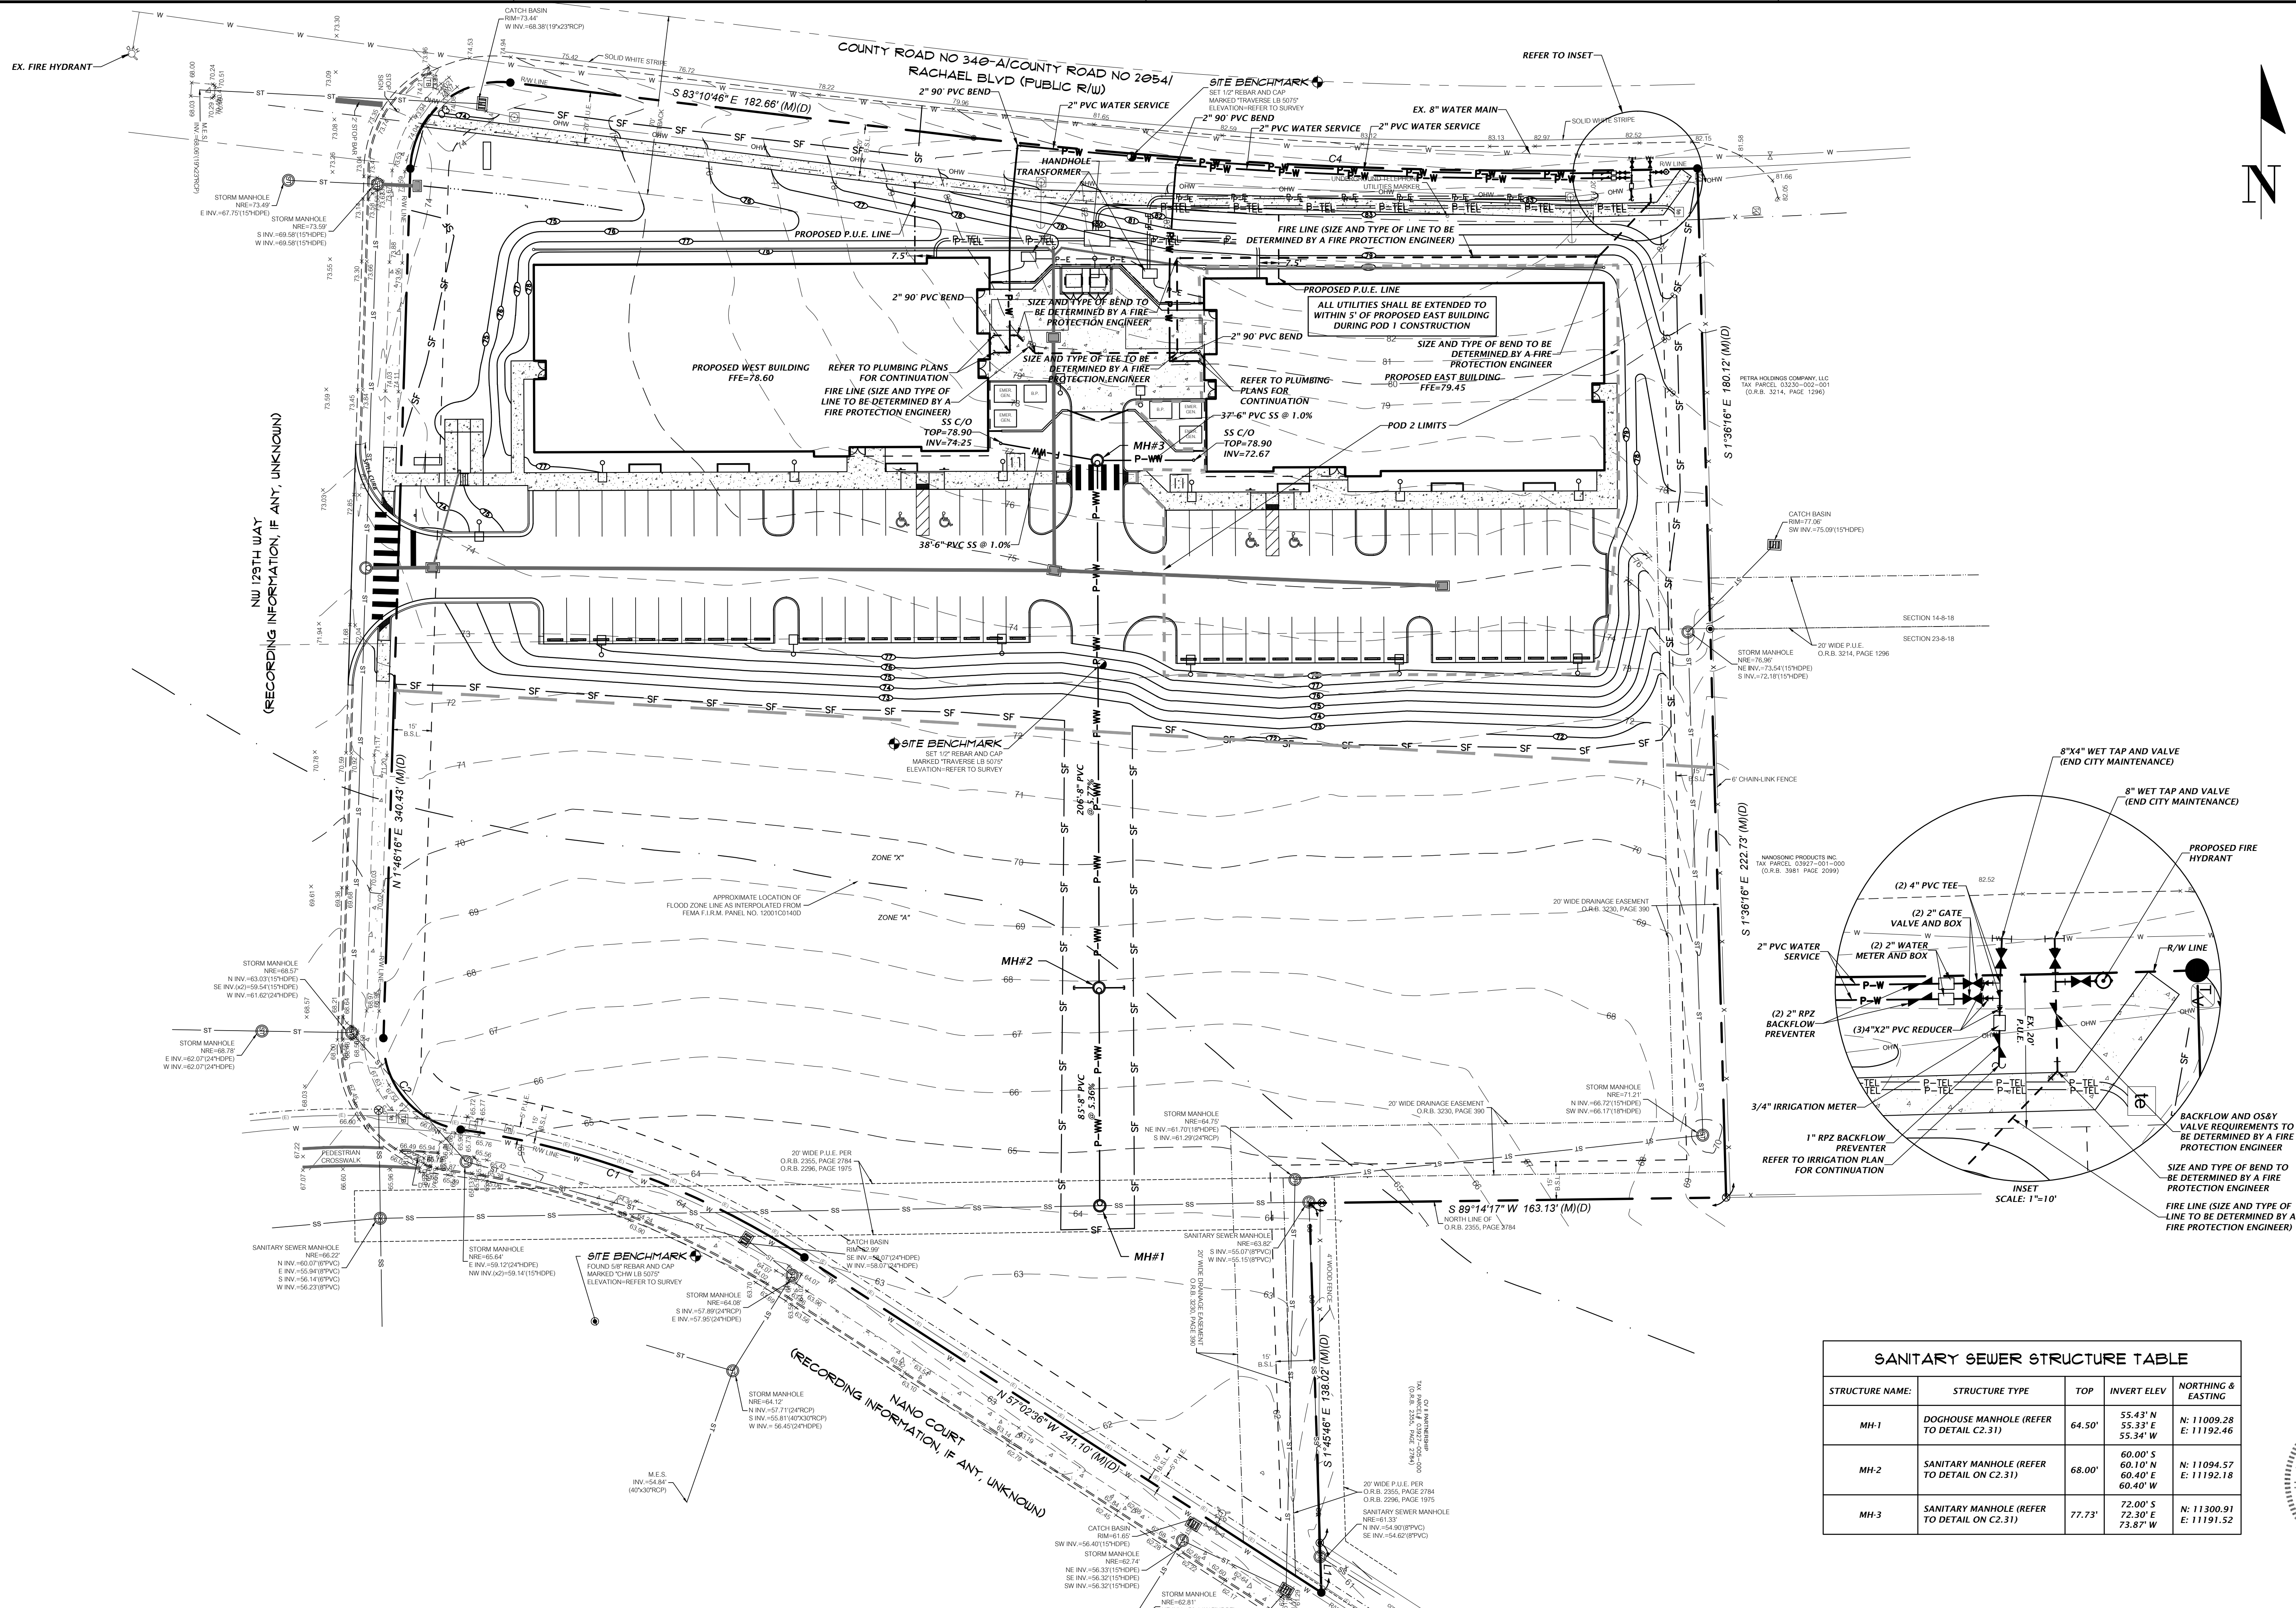

SANITARY SEWER STRUCTURE TABLE				
STRUCTURE NAME:	STRUCTURE TYPE	TOP	INVERT ELEV	NORTHING & EASTING
MH-1	DOCHOUSE MANHOLE (REFER TO DETAIL C.31)	64.50'	55.43' N 55.33' E 55.34' W	N: 11009.28 E: 11192.46
MH-2	SANITARY MANHOLE (REFER TO DETAIL ON C.31)	68.00'	60.00' S 60.10' N 60.40' E 60.40' W	N: 11094.57 E: 11192.18
MH-3	SANITARY MANHOLE (REFER TO DETAIL ON C.31)	77.73'	72.00' S 72.30' E 73.87' W	N: 11300.91 E: 11191.52



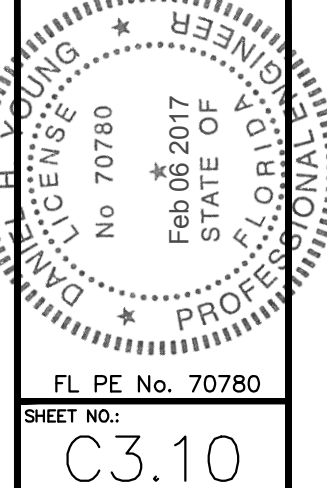

**NOT FOR
CONSTRUCTION**

CONSULTANTS

[illegible]

DATE ISSUED:	10/31/16
REVIEWED BY:	MPV
DRAWN BY:	ALM
DESIGNED BY:	RSC

501-0139-000
© 2015 RS&H, INC.

SHEET TITLE

FLOOR PLAN

SHEET NUMBER

A-101

SITE SUBMITTAL





**NOT FOR
CONSTRUCTION**

CONSULTANTS

[illegible]

DATE ISSUED:	10/31/16
REVIEWED BY:	MPV
DRAWN BY:	ALM
DESIGNED BY:	RSC

501-0139-000
© 2015 RS&H, INC.

SHEET TITLE

FLOOR PLAN

SHEET NUMBER

A-102

SITE SUBMITTAL





**NOT FOR
CONSTRUCTION**

[illegible]

501-0139-000
© 2016 RS&H, INC.

SHEET TITLE

SHEET TITLE

SHEET NUMBER

SITE SUBMITTAL



SCALE: 1/8" = 1'-0"



SCALE: 1/8" = 1'-0"



SCALE: 1/8" = 1'-0"



SCALE: 1/8" = 1'-0"



SCALE: 1/8" = 1'-0"



SCALE: 1/8" = 1'-0"



SCALE: 1/8" = 1'-0"



ALACHUA, FLORIDA

**NOT FOR
CONSTRUCTION**

CONSULTANTS



REVISIONS

[illegible]

DATE ISSUED: 10/31/16

REVIEWED BY: MPV

DRAWN BY: **ALM**

DESIGNED BY: RSC

501-0139-000

© 2015 RS&H, INC.

SHEET TITLE

EXTERIOR ELEVATIONS

SHEET NUMBER

A-302

SITE SUBMITTAL



SCALE: 1/8" = 1'-0"



SCALE: 1/8" = 1'-0"



SCALE: 1/8" = 1'-0"



SCALE: 1/8" = 1'-0"



SCALE: 1/8" = 1'-0"

1
2
3
4
A
B
C
D
Title: callit Plot Date: Feb 03,2017 8:01 pm Filename: L:\2016\16-0386\Design\03_Production\02_SRF\02_Current\16-386-design-base.dwg

30% LANDSCAPED AREA REQUIREMENT
Per City of Alachua Comprehensive Plan Future Land Use
Element, Objective 2.4, Policy 2.4.a

POD 1
TOTAL SITE AREA..... 229,256 S.F.
TOTAL PROPOSED LANDSCAPED AREA..... 73,091 S.F.
LANDSCAPED AREA % OF TOTAL SITE AREA..... 31.9% (MIN. 30%)
POD 2
TOTAL SITE AREA..... 229,256 S.F.
TOTAL PROPOSED LANDSCAPED AREA..... 76,690 S.F.
LANDSCAPED AREA % OF TOTAL SITE AREA..... 33.5% (MIN. 30%)

PARKING AREA LANDSCAPE REQUIREMENTS [Sec. 6.2.2(D)(2)(a) & (b)]

DESCRIPTION	LANDSCAPE REQUIRED	LANDSCAPE PROVIDED
PARKING AREA PERIMETER LANDSCAPE (POD 1)	PARKING PERIMETER = 310 L.F. 4 CANOPY TREES PER 100 L.F. 2 UNDERSTORY/ORNAMENTAL PER 100 L.F. CONTINUOUS ROW OF SHRUBS 13 CANOPY TREES REQUIRED 7 UNDERSTORY TREES REQUIRED CONTINUOUS ROW OF SHRUBS	13 CANOPY TREES PROVIDED 7 UNDERSTORY TREES PROVIDED CONTINUOUS ROW OF SHRUBS PROVIDED
INTERIOR PARKING AREA LANDSCAPE (POD 1)	PARKING AREA = 13,337 S.F. 1 CANOPY TREE REQUIRED PER 2,000 S.F. 10 SHRUBS REQUIRED PER CANOPY TREE REQUIRED 7 CANOPY TREES REQUIRED 70 SHRUBS REQUIRED	7 CANOPY TREES PROVIDED 70 SHRUBS PROVIDED
PARKING AREA PERIMETER LANDSCAPE (POD 2)	PARKING PERIMETER = 475 L.F. 4 CANOPY TREES PER 100 L.F. 2 UNDERSTORY/ORNAMENTAL PER 100 L.F. CONTINUOUS ROW OF SHRUBS 19 CANOPY TREES REQUIRED 10 UNDERSTORY TREES REQUIRED CONTINUOUS ROW OF SHRUBS	19 CANOPY TREES PROVIDED 10 UNDERSTORY TREES PROVIDED CONTINUOUS ROW OF SHRUBS PROVIDED
INTERIOR PARKING AREA LANDSCAPE (POD 2)	PARKING AREA = 22,834 S.F. 1 CANOPY TREE REQUIRED PER 2,000 S.F. 10 SHRUBS REQUIRED PER CANOPY TREE REQUIRED 12 CANOPY TREES REQUIRED 120 SHRUBS REQUIRED	12 CANOPY TREES PROVIDED 120 SHRUBS PROVIDED

SITE LANDSCAPE CALCULATIONS [Sec. 6.2.2(D)(1)(c)]

DESCRIPTION	TREE REQUIREMENTS	TREES PROVIDED
PRIMARY SIDE CANOPY TREES (NORTH SIDE, ENTIRE SITE)	3 TREES PER ACRE X 5.26 ACRES = 16 CANOPY TREES REQUIRED	16 CANOPY TREES PROVIDED
REAR SIDE CANOPY TREES (SOUTH SIDE, ENTIRE SITE)	2 TREES PER ACRE X 5.26 ACRES = 11 TREES REQUIRED	11 CANOPY TREES PROVIDED
EAST SIDE CANOPY TREES	2 TREES PER ACRE X 5.26 ACRES = 11 TREES REQUIRED	11 CANOPY TREES PROVIDED
WEST SIDE CANOPY TREES (ENTIRE SITE)	2 TREES PER ACRE X 5.26 ACRES = 11 TREES REQUIRED	11 CANOPY TREES PROVIDED
SITE UNDERSTORY TREES (ENTIRE SITE)	6 UNDERSTORY TREES PER ACRE X 5.26 ACRES = 32 TREES REQUIRED 50% IN FRONT (NORTH) = 16 TREES REQUIRED 25% ON EAST SIDE = 8 TREES REQUIRED 25% ON WEST SIDE = 8 TREES REQUIRED 32 UNDERSTORY TREES REQUIRED	FRONT (NORTH) SIDE 16 UNDERSTORY TREES PROVIDED EAST SIDE 8 UNDERSTORY TREES PROVIDED WEST SIDE 8 UNDERSTORY TREES PROVIDED 32 UNDERSTORY TREES PROVIDED
POD 1 BUILDING FACADE	541 LINEAR FEET 4 CANOPY TREES PER 100 LIN. FT. REQUIRED = 22 CANOPY TREES REQUIRED + ROW OF SHRUBS	22 CANOPY TREES PROVIDED ROW OF SHRUBS PROVIDED
POD 2 BUILDING FACADE	497 LINEAR FEET 4 CANOPY TREES PER 100 LIN. FT. REQUIRED = 20 CANOPY TREES REQUIRED + ROW OF SHRUBS	20 CANOPY TREES PROVIDED ROW OF SHRUBS PROVIDED


PERIMETER BUFFER LANDSCAPE REQUIREMENTS [Section 6.2.2(D)(3)]

LOCATION	BUFFER LENGTH & TYPE	LANDSCAPE REQUIRED	LANDSCAPE PROVIDED
EASTERN PERIMETER	719 L.F. BUFFER TYPE 'B'	OPTION 2 (1) CANOPY TREE / 40 LIN. FT. + CONTINUOUS HEDGE	18 PROPOSED CANOPY TREES + CONTINUOUS HEDGE
WESTERN PERIMETER	386 L.F. BUFFER TYPE 'B'	OPTION 2 (1) CANOPY TREE / 40 LIN. FT. + CONTINUOUS HEDGE	10 PROPOSED CANOPY TREES + CONTINUOUS HEDGE
SOUTHERN PERIMETER	450 L.F. BUFFER TYPE 'B'	OPTION 2 (1) CANOPY TREE / 40 LIN. FT. + CONTINUOUS HEDGE	12 PROPOSED CANOPY TREES + CONTINUOUS HEDGE


PLANT SCHEDULE

TREES	QTY	BOTANICAL NAME	COMMON NAME	SIZE
INS	18	ILEX X 'NELLIE R. STEVENS'	NELLIE R. STEVENS HOLLY	1.5" CAL., MIN.
LIM	13	LAGERSTROEMIA INDICA 'MUSKOGEE'	MUSKOGEE CRAPE MYRTLE	1.5" CAL., MIN.
LT	17	LIRIODENDRON TULIIFERA	TULIP TREE	8' HT., MIN.
MG	45	MAGNOLIA GRANDIFLORA 'DD BLANCHARD'	DD BLANCHARD MAGNOLIA	8' HT., MIN.
QA	6	QUERCUS AUSTRINA	BLUFF OAK	8' HT., MIN.
QVP	18	QUERCUS VIRGINIANA 'PARK SIDE'	PARK SIDE LIVE OAK	8' HT., MIN.
TD	29	TAXODIUM DISTICHUM	BALD CYPRESS	8' HT., MIN.
PALM TREES	QTY	BOTANICAL NAME	COMMON NAME	SIZE
SP	11	SABAL PALMETTO	CABBAGE PALM	12" C.T., 12" MIN. DBH, REGENERATED
SHRUBS	QTY	BOTANICAL NAME	COMMON NAME	SIZE
BX	158	BUXUS MICROPHYLLA	BOXWOOD	24" HT., MIN.
DV	52	DIETES VEGETA	AFRICAN IRIS	24" HT., MIN.
IDB	564	ILEX CORNUTA 'DWARF BURFORDII'	DWARF BURFORD HOLLY	24" HT., MIN.
PD	292	PODOCARPUS MACROPHYLLUS 'DWARF PRINGLES'	DWARF PODOCARPUS	24" HT., MIN.
RI	58	RHAPHIOLEPIS INDICA 'ELEANOR TABER'	INDIAN HAWTHORN 'ELEANOR TABER'	24" HT., MIN.
VOS	64	VIBURNUM OBOVATUM 'MRS. SCHILLER'S DELIGHT'	MRS. SCHILLER'S DELIGHT VIBURNUM	24" HT., MIN.
SOD/SEED		BOTANICAL NAME	COMMON NAME	SIZE
SOD		PASPALUM NOTATUM 'ARGENTINE'	BAHIA GRASS	WEED FREE AND SAND GROWN SOD

LEGEND

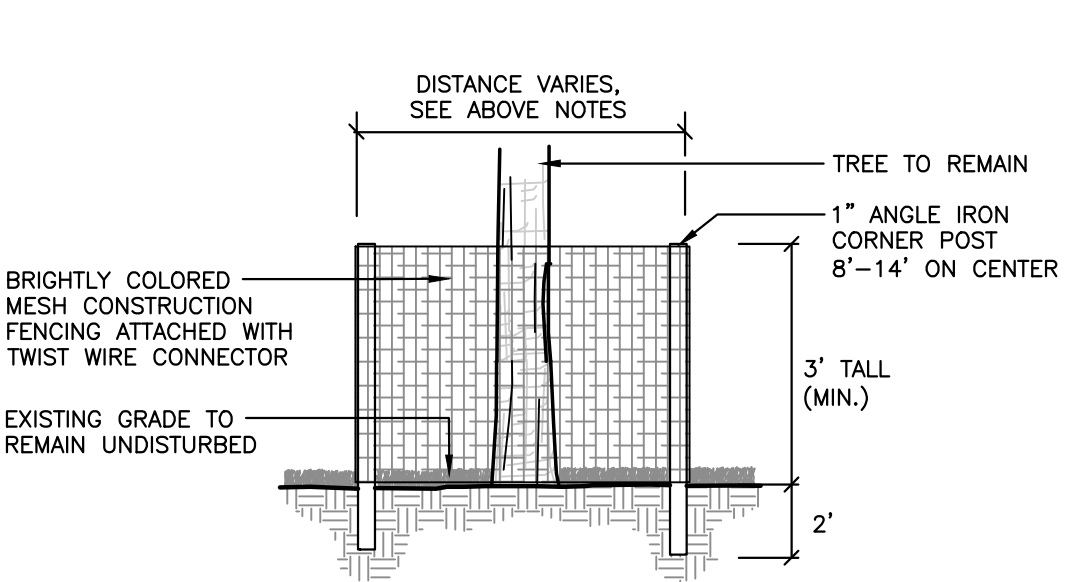

1 TREE PROTECTION DETAIL
SCALE: N.T.S.

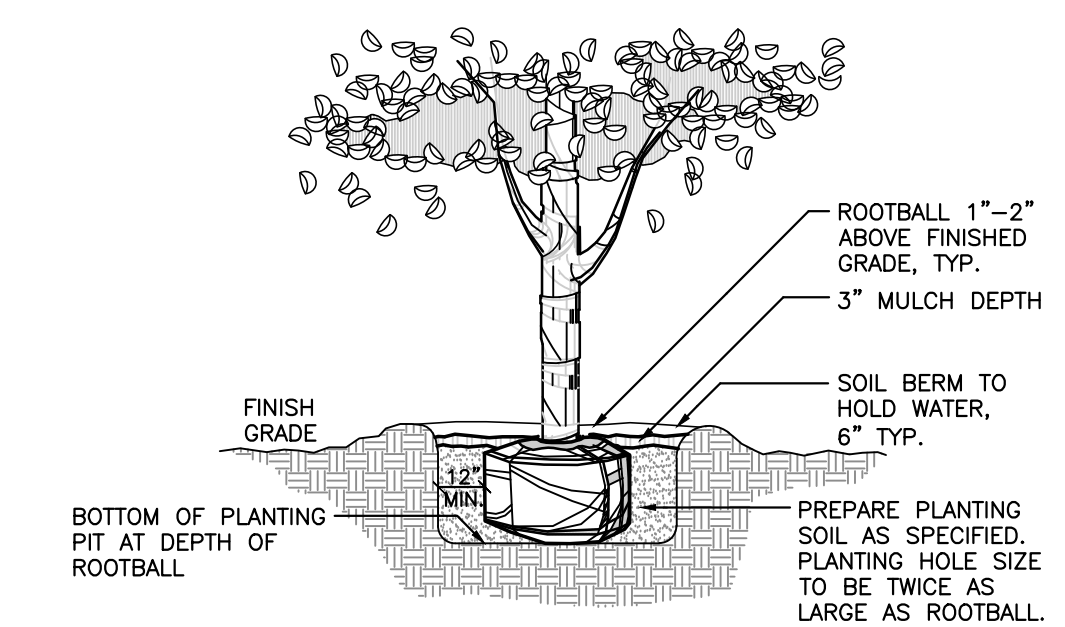

2 TREE PLANTING DETAIL
SCALE: N.T.S.

GENERAL NOTES
ALL ASPHALT, LIMESTONE, AND CONSTRUCTION DEBRIS TO BE REMOVED FROM PLANTING BEDS AND AREAS TO BE SODDED PRIOR TO LANDSCAPE INSTALLATION. PLANTING DEPTH OF SOIL IN SUCH AREAS SHOULD BE AT LEAST 3". IF FILL MUST BE ADDED, IT MUST BE FLORIDA CLEAN DEEP FILL (FREE OF WEED SEEDS) SANDY LOAM WITH pH 5.5-6.5.
CANOPY TREES SHALL BE A MINIMUM OF EIGHT (8) FEET IN HEIGHT AND ORNAMENTAL OR UNDERSTORY TREES SHALL HAVE A MINIMUM CALIPER OF ONE AND A HALF (1.5) INCHES, UNLESS OTHERWISE SPECIFIED BY THE LANDSCAPE ARCHITECT.
ALL TREES TO BE PLANTED 1"-2" ABOVE FINISHED GRADE.
ALL LANDSCAPED AREAS TO BE MULCHED WITH 3" THICKNESS OF MULCH. PINE BARK MULCH SHALL BE USED IN ALL AREAS.
LEADER SHOOTS AND MAIN STRUCTURAL LIMBS OF TREES WILL NOT BE TOPPED OR PRUNED. TREES TO BE STAKED AS NEEDED, GUTLINES TO BE NON-SYNTHETIC BIODEGRADABLE MATERIAL.
OWNER SHALL BE RESPONSIBLE FOR (1) THE SURVIVAL OF THE LANDSCAPING ELEMENTS AND (2) REMOVAL OF ALL STAKING SYSTEMS WITHIN ONE YEAR. TREES WILL BE STAKED ONLY IF NECESSARY, AND IF STAKED, BIODEGRADABLE TWINE WILL BE USED.
GRASSING
ALL DISTURBED AND UNPAVED AREAS TO BE GRASSED WITH NOXIOUS WEED AND TROPICAL SODA APPLE FREE SOD OR SEEDED AND MULCHED. SEE CIVIL SITE PLANS FOR ADDITIONAL RELATED INFORMATION.
PLANT MATERIAL
ALL PLANT MATERIAL TO BE FLORIDA NO.1 OR BETTER, GRADED IN ACCORDANCE WITH GRADES AND STANDARDS FOR NURSERY PLANTS PUBLISHED BY THE STATE OF FLORIDA, DEPARTMENT OF AGRICULTURE.
10% OPEN SPACE REQUIREMENT
CITY OF ALACHUA LDR SECTION 6.7.3 (A) STATES THAT THE MINIMUM OPEN SPACE SET ASIDE SHALL BE 10% OF THE DEVELOPMENT SITE. SEE CIVIL PLANS FOR OPEN SPACE CALCULATIONS.
IRRIGATION
LANDSCAPE IRRIGATION TO BE PROVIDED BY AUTOMATIC IRRIGATION SYSTEM IN ACCORDANCE WITH CITY OF ALACHUA LDR SECTION 6.2.2(D)(6)(B)(VI). SEE SHEETS IR-1 AND IR-3 FOR IRRIGATION PLANS.

132 NW 76th Drive
Gainesville, Florida 32607
(882) 331-1976 / (882) 331-2476
www.chw-ho.com

CHW
Professional Consultants

SCALE: N/A
PER SITE SCALE
BASED ON ORIGINAL DRAWING
0 INCHES = 1 FOOT
DO NOT SCALE DRAWING
THIS SHEET, ADJUST
SCALES ACCORDINGLY.


CONSTRUCTION/DBI REVISIONS



REVISIONS
10/31/16 CITY OF ALACHUA REVIEW
11/23/16 CITY OF ALACHUA REVIEW
01/05/16 CITY OF ALACHUA REVIEW
02/03/17 CITY OF ALACHUA REVIEW

CLIENT: CONCEPT DEVELOPMENT, INC.
PROJECT: COPELAND PARK PHASE I
SHEET TITLE: LANDSCAPE NOTES & DETAILS

DESIGNER: C. TOLAR
DESIGNER: C. TOLAR
QUALITY CONTROL: L. HALL
PROJECT NUMBER: 16-0386

SHEET NO.: LS-1

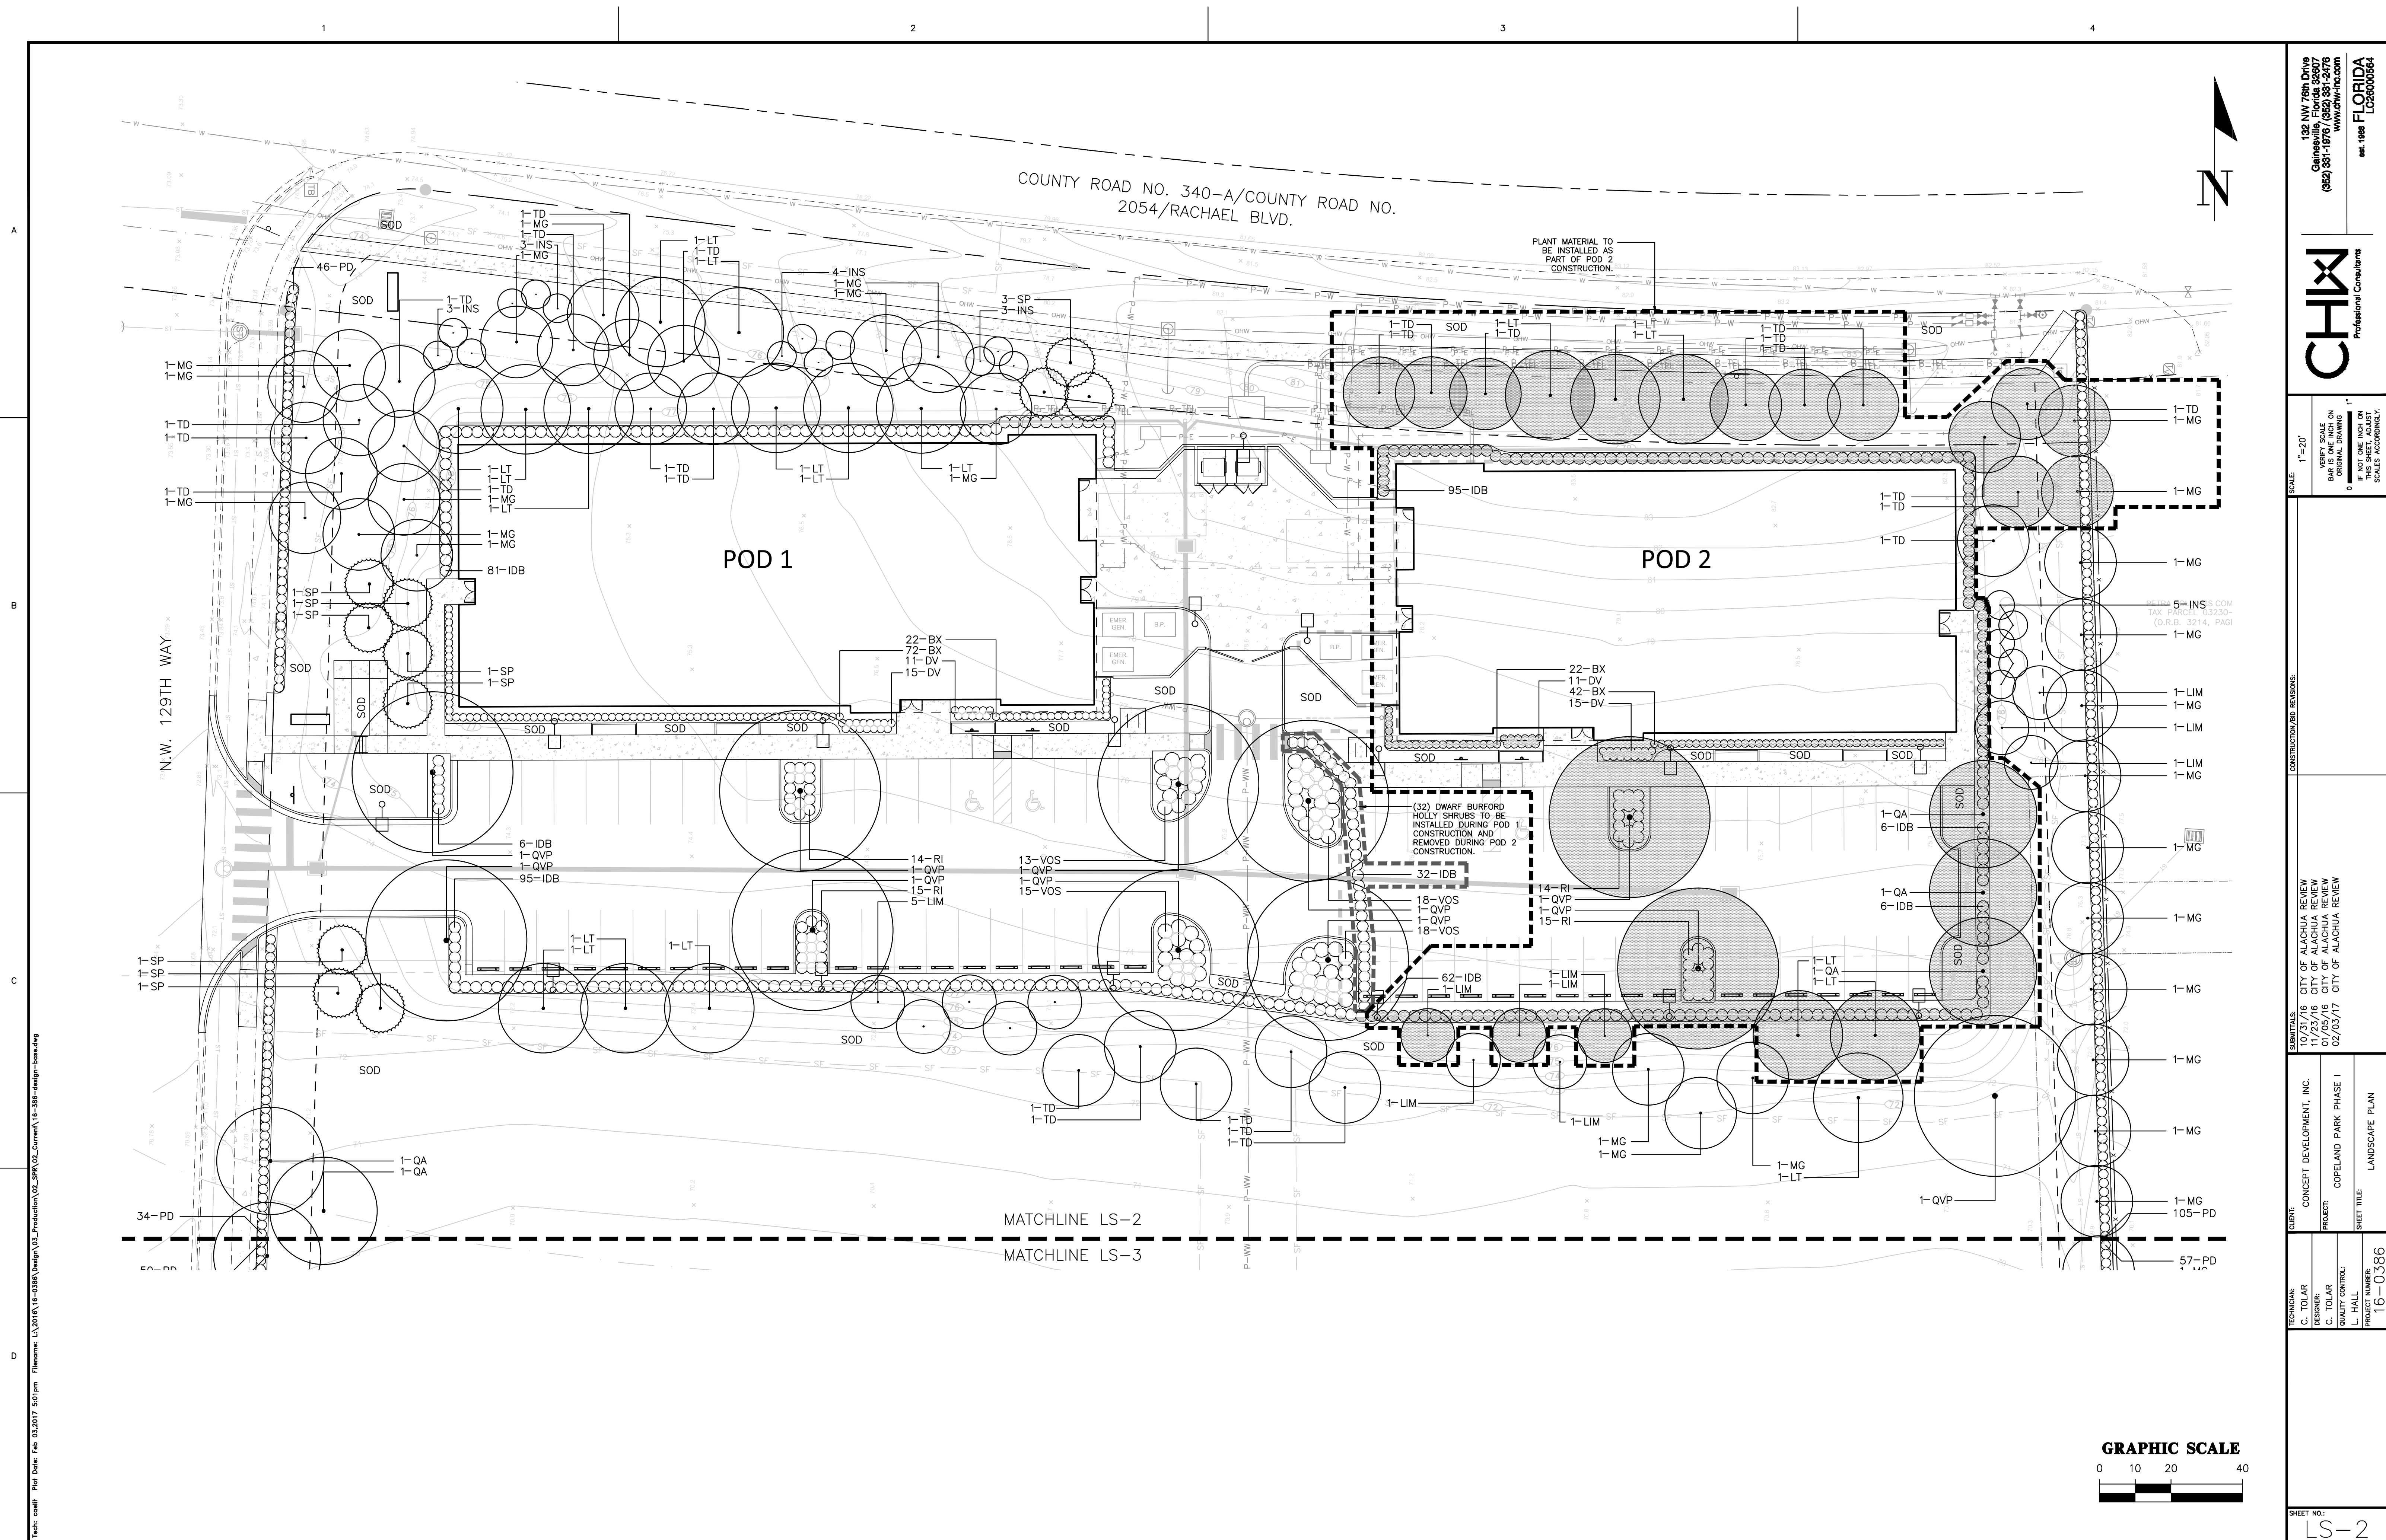

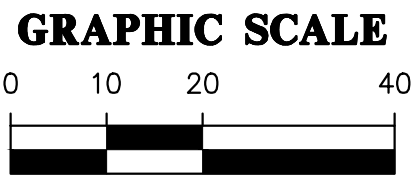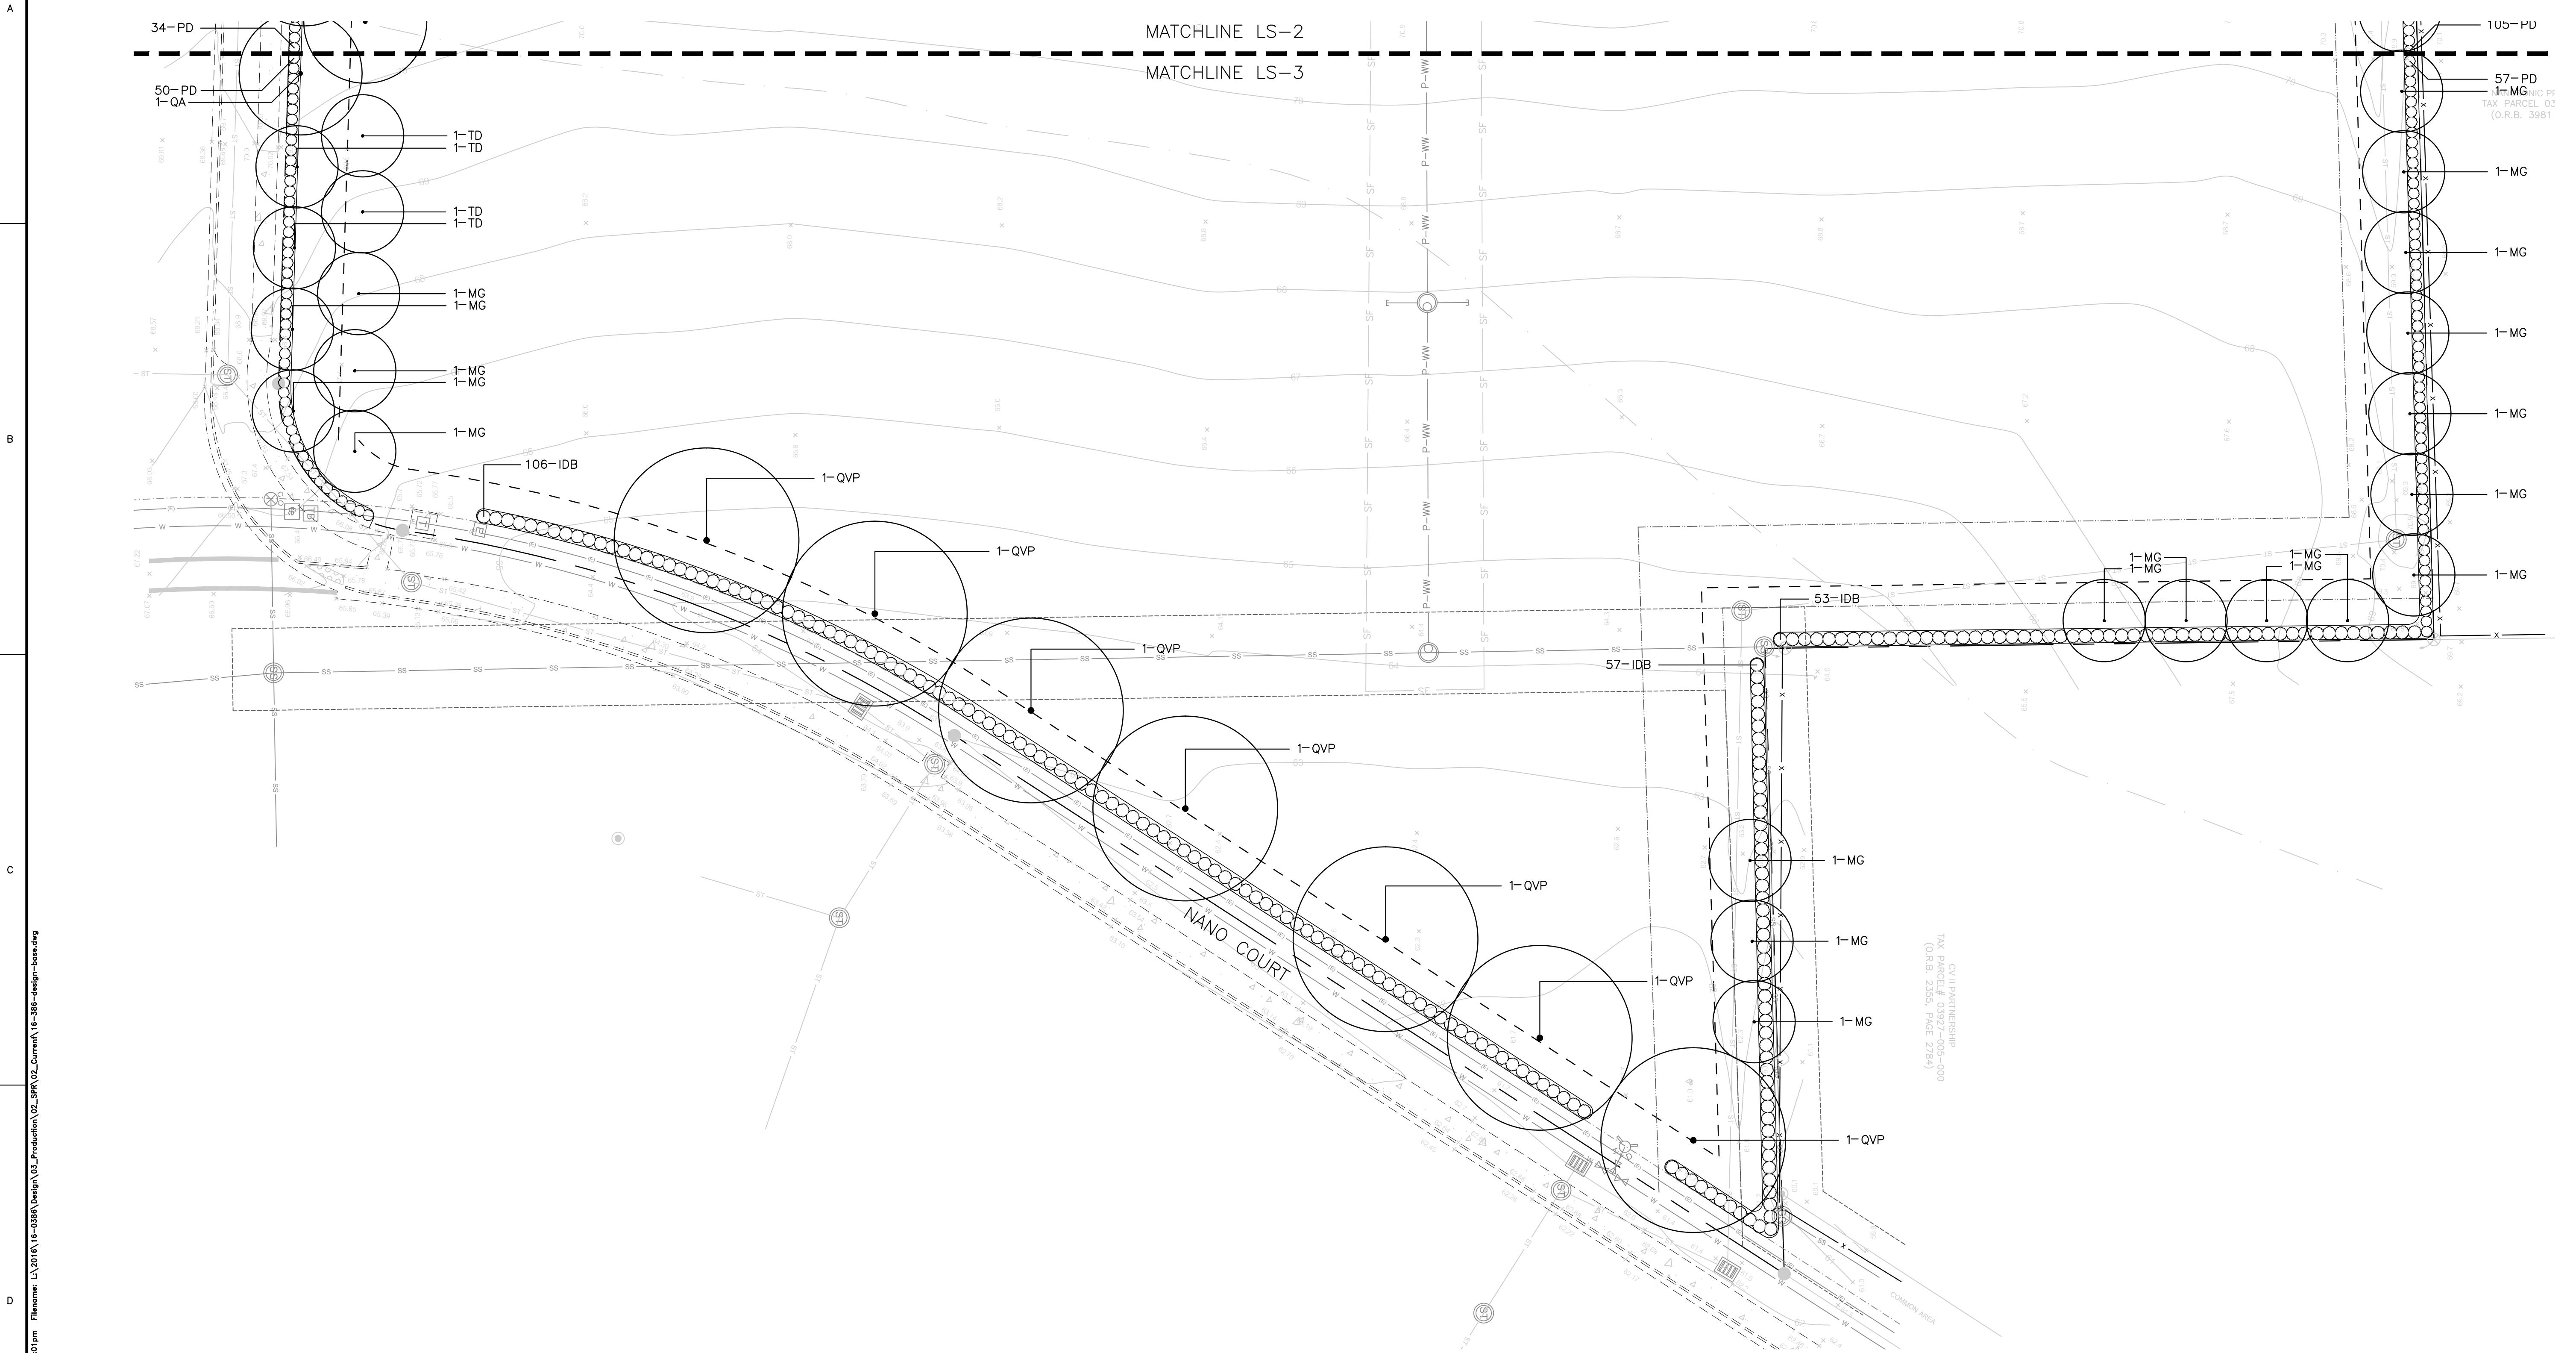

132 NW 78th Drive
Gainesville, Florida 32607
(882) 331-1976 / (882) 331-2476
www.chw-ho.com

CHW
Professional Consultants

SCALE: 1"=20'
FOR SCALE ON
PARCEL MAPS
OR ORIGINAL DRAWING
0' 10' 20' 30' 40'
DO NOT SCALE DRAWING
THIS SHEET, ADJUST
SCALES ACCORDINGLY.

CONSTRUCTION/REVISIONS

DATE/TITLE
10/23/16 CITY OF ALACHUA REVIEW
11/23/16 CITY OF ALACHUA REVIEW
01/05/16 CITY OF ALACHUA REVIEW
02/03/17 CITY OF ALACHUA REVIEW


CLIENT: CONCEPT DEVELOPMENT, INC.
PROJECT: COPELAND PARK PHASE I
SHEET TITLE: LANDSCAPE PLAN

DESIGNER: C. TOLAR
DESIGNER: C. TOLAR
QUALITY CONTROL: L. HALL
PROJECT NUMBER: 16-0386


SHEET NO.: LS-3

6 IRREGULAR AREA DRIPLINE INSTALLATION DETAIL
N.T.S.

NUMBER	MODEL	TYPE	PRECIP	GPM
<u>PHASE 1</u>				
1	Hunter	Area for Dripline	1.16 in/h	15.0
2	Hunter	Area for Dripline	1.16 in/h	15.0
3	Hunter	Area for Dripline	1.16 in/h	17.0
4	Hunter	Area for Dripline	1.16 in/h	13.5
5	Hunter	Area for Dripline	1.16 in/h	19.0
6	Hunter	Area for Dripline	1.16 in/h	16.0
7	Hunter	Bubbler	NA	14.0
8	Hunter	Area for Dripline	1.16 in/h	18.0
<u>PHASE 2</u>				
9	Hunter	Area for Dripline	1.16 in/h	16.0
10	Hunter	Area for Dripline	1.16 in/h	15.0

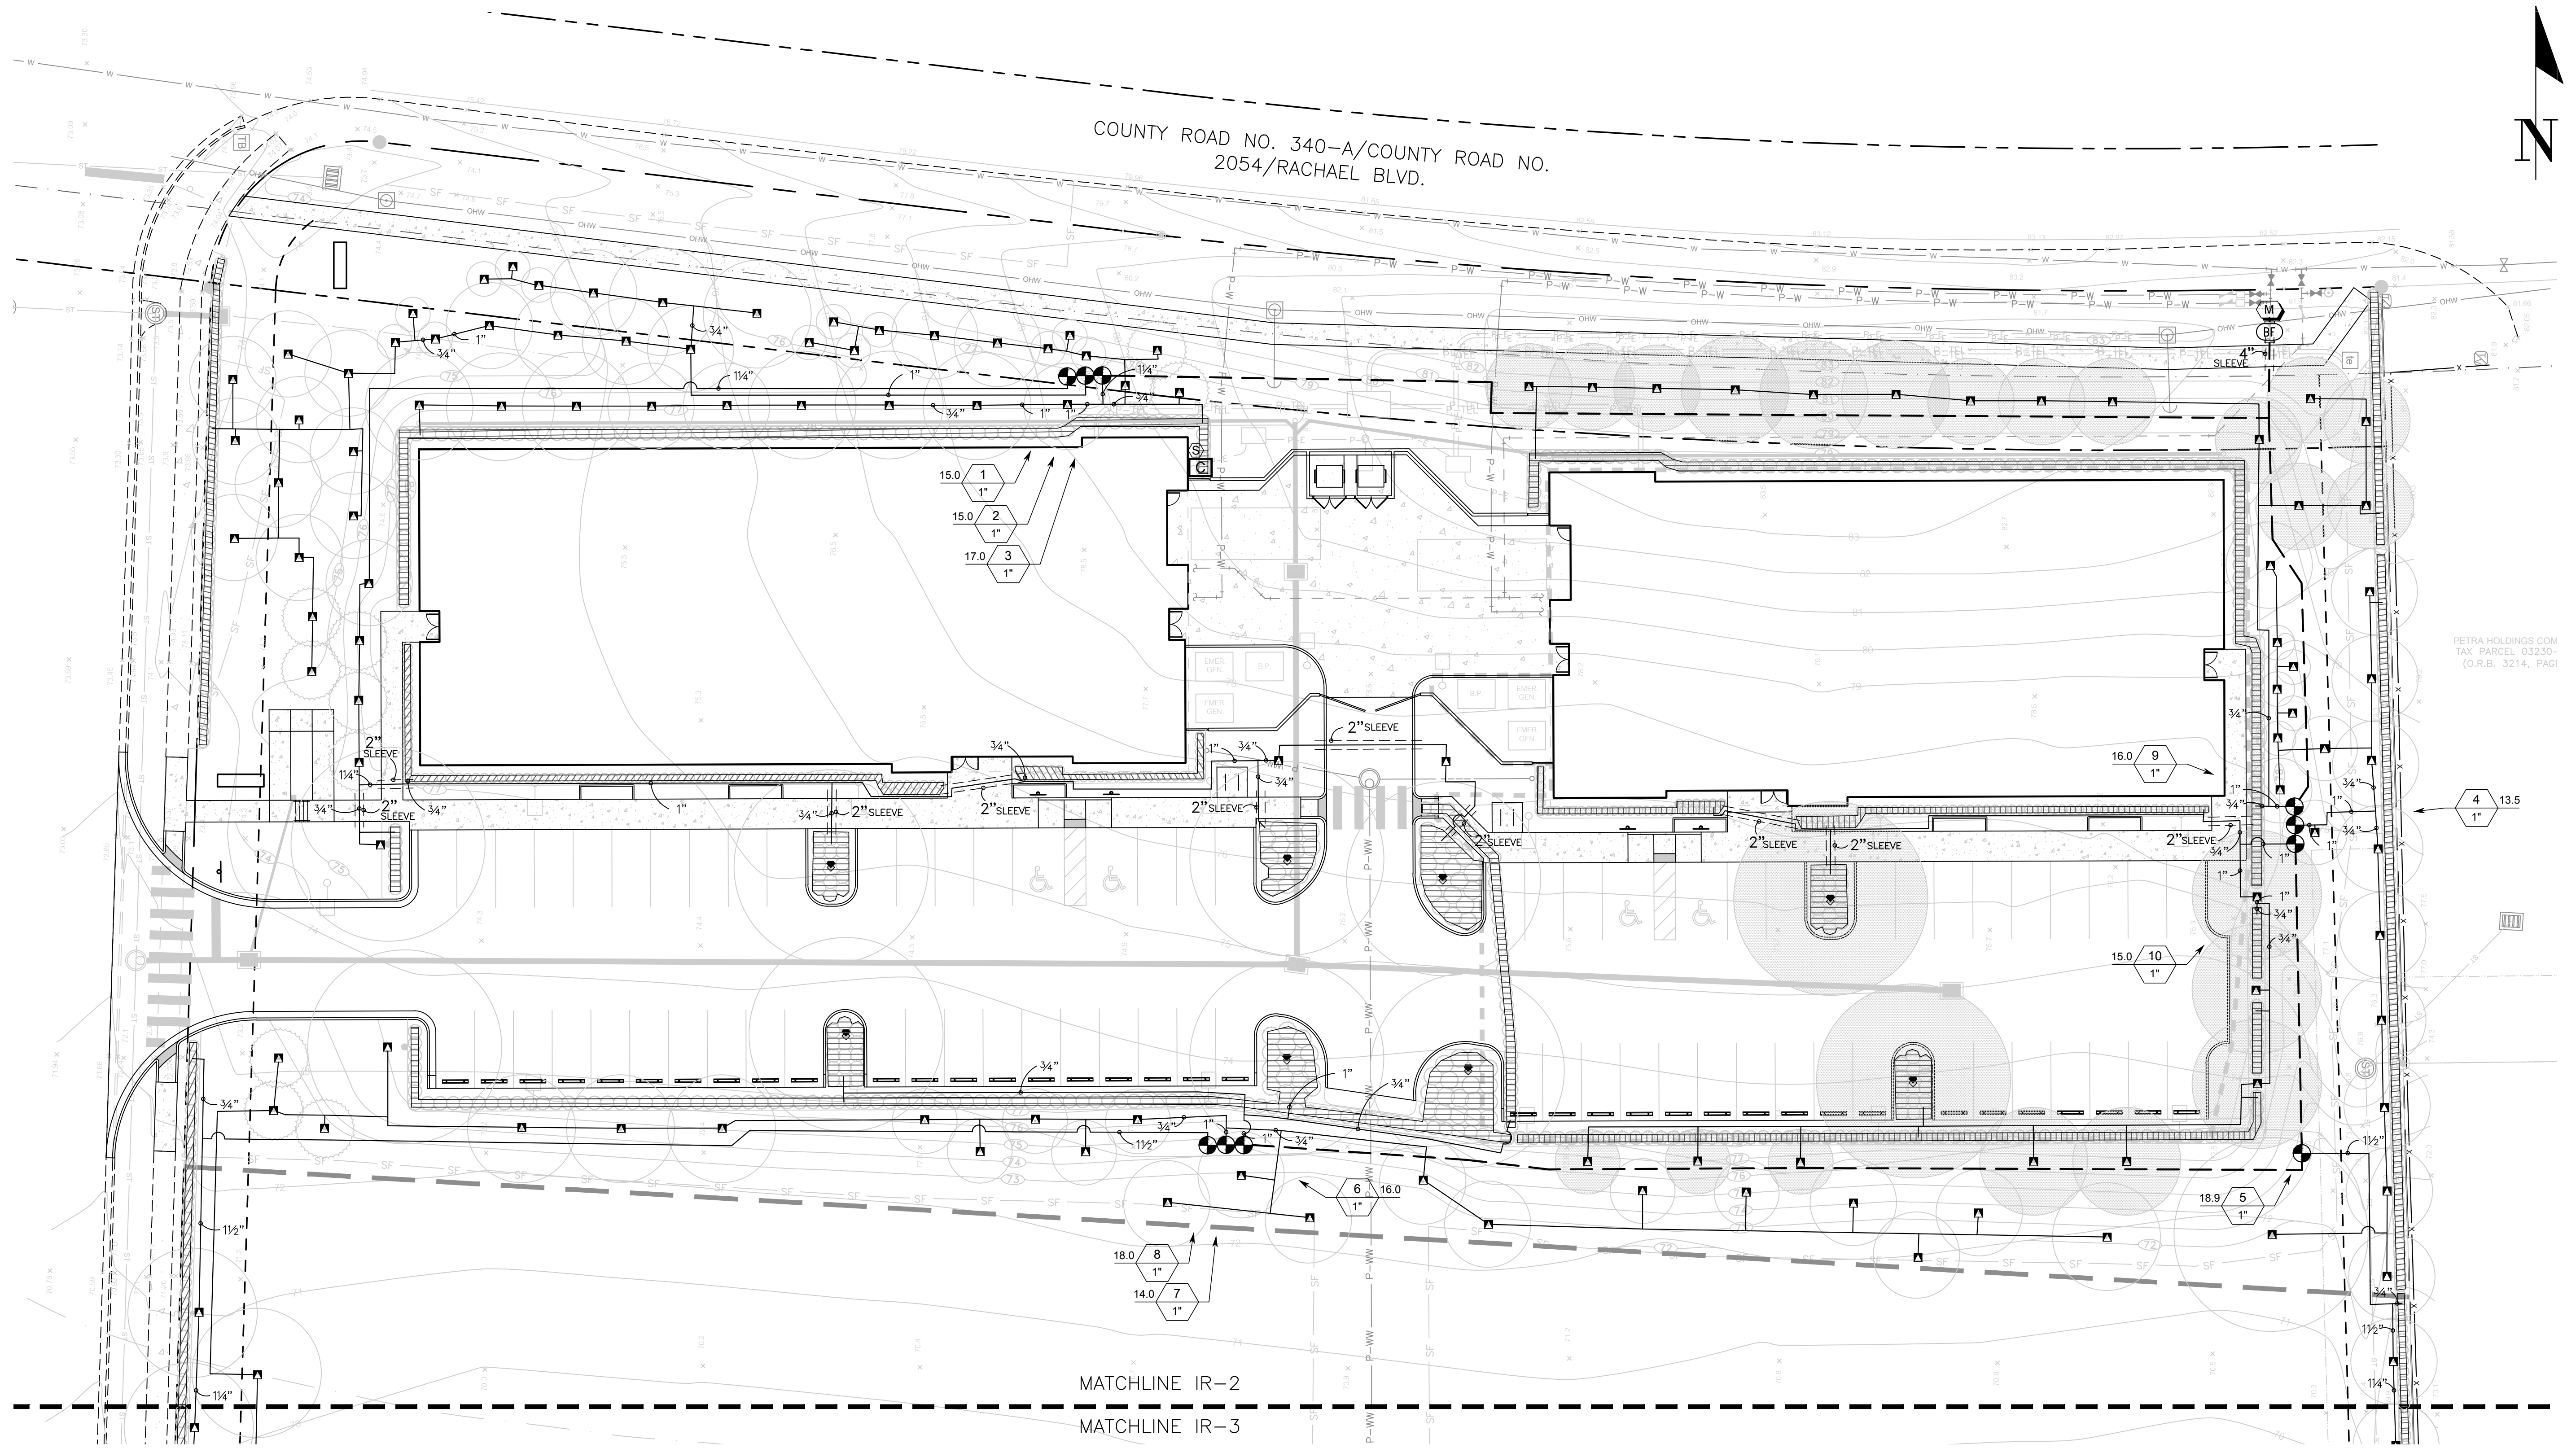



COUNTY ROAD NO. 340-A/COUNTY ROAD NO.
2054/RACHAEL BLVD.

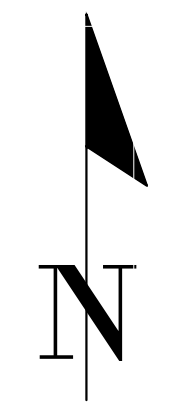






KNOW WHAT'S
BELOW
ALWAYS CALL 811
BEFORE YOU DIG
It's fast, it's free, it's the law.
Call 811 two business days
before digging

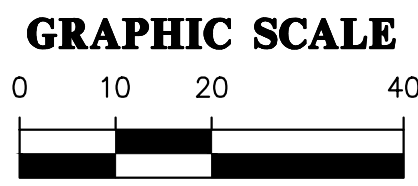

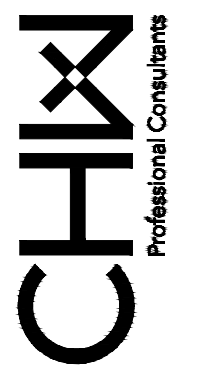DESIGNER: C. TOLAR		CLIENT: CONCEPT DEVELOPMENT, INC.	DATE: 10/31/16	CITY OF ALACHUA REVIEW	SCALE: 1"=20'	 Professional Consultants
DESIGNER: C. TOLAR		PROJECT: COPELAND PARK PHASE I	DATE: 11/23/16	CITY OF ALACHUA REVIEW	AS SHOWN ON ORIGINAL DRAWING	
QUALITY CONTROL: L. HALL		SHEET TITLE: IRRIGATION PLAN	DATE: 02/03/17	CITY OF ALACHUA REVIEW	IF ANY ONE INQUIRY THIS SHEET, ADJUST SCALES ACCORDINGLY.	
PROJECT NUMBER: 16-0366		SHEET NO.: IR-2				

132 NW 78th Drive
Gainesville, Florida 32607
(882) 331-1976 / (882) 331-2476
www.ch2m.com


est. 1988 FLORIDA
LC2800564

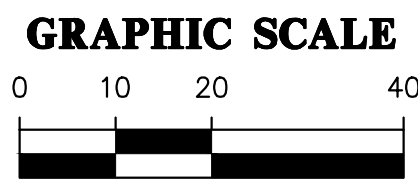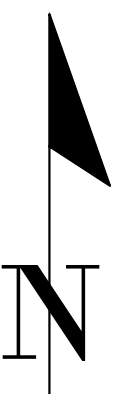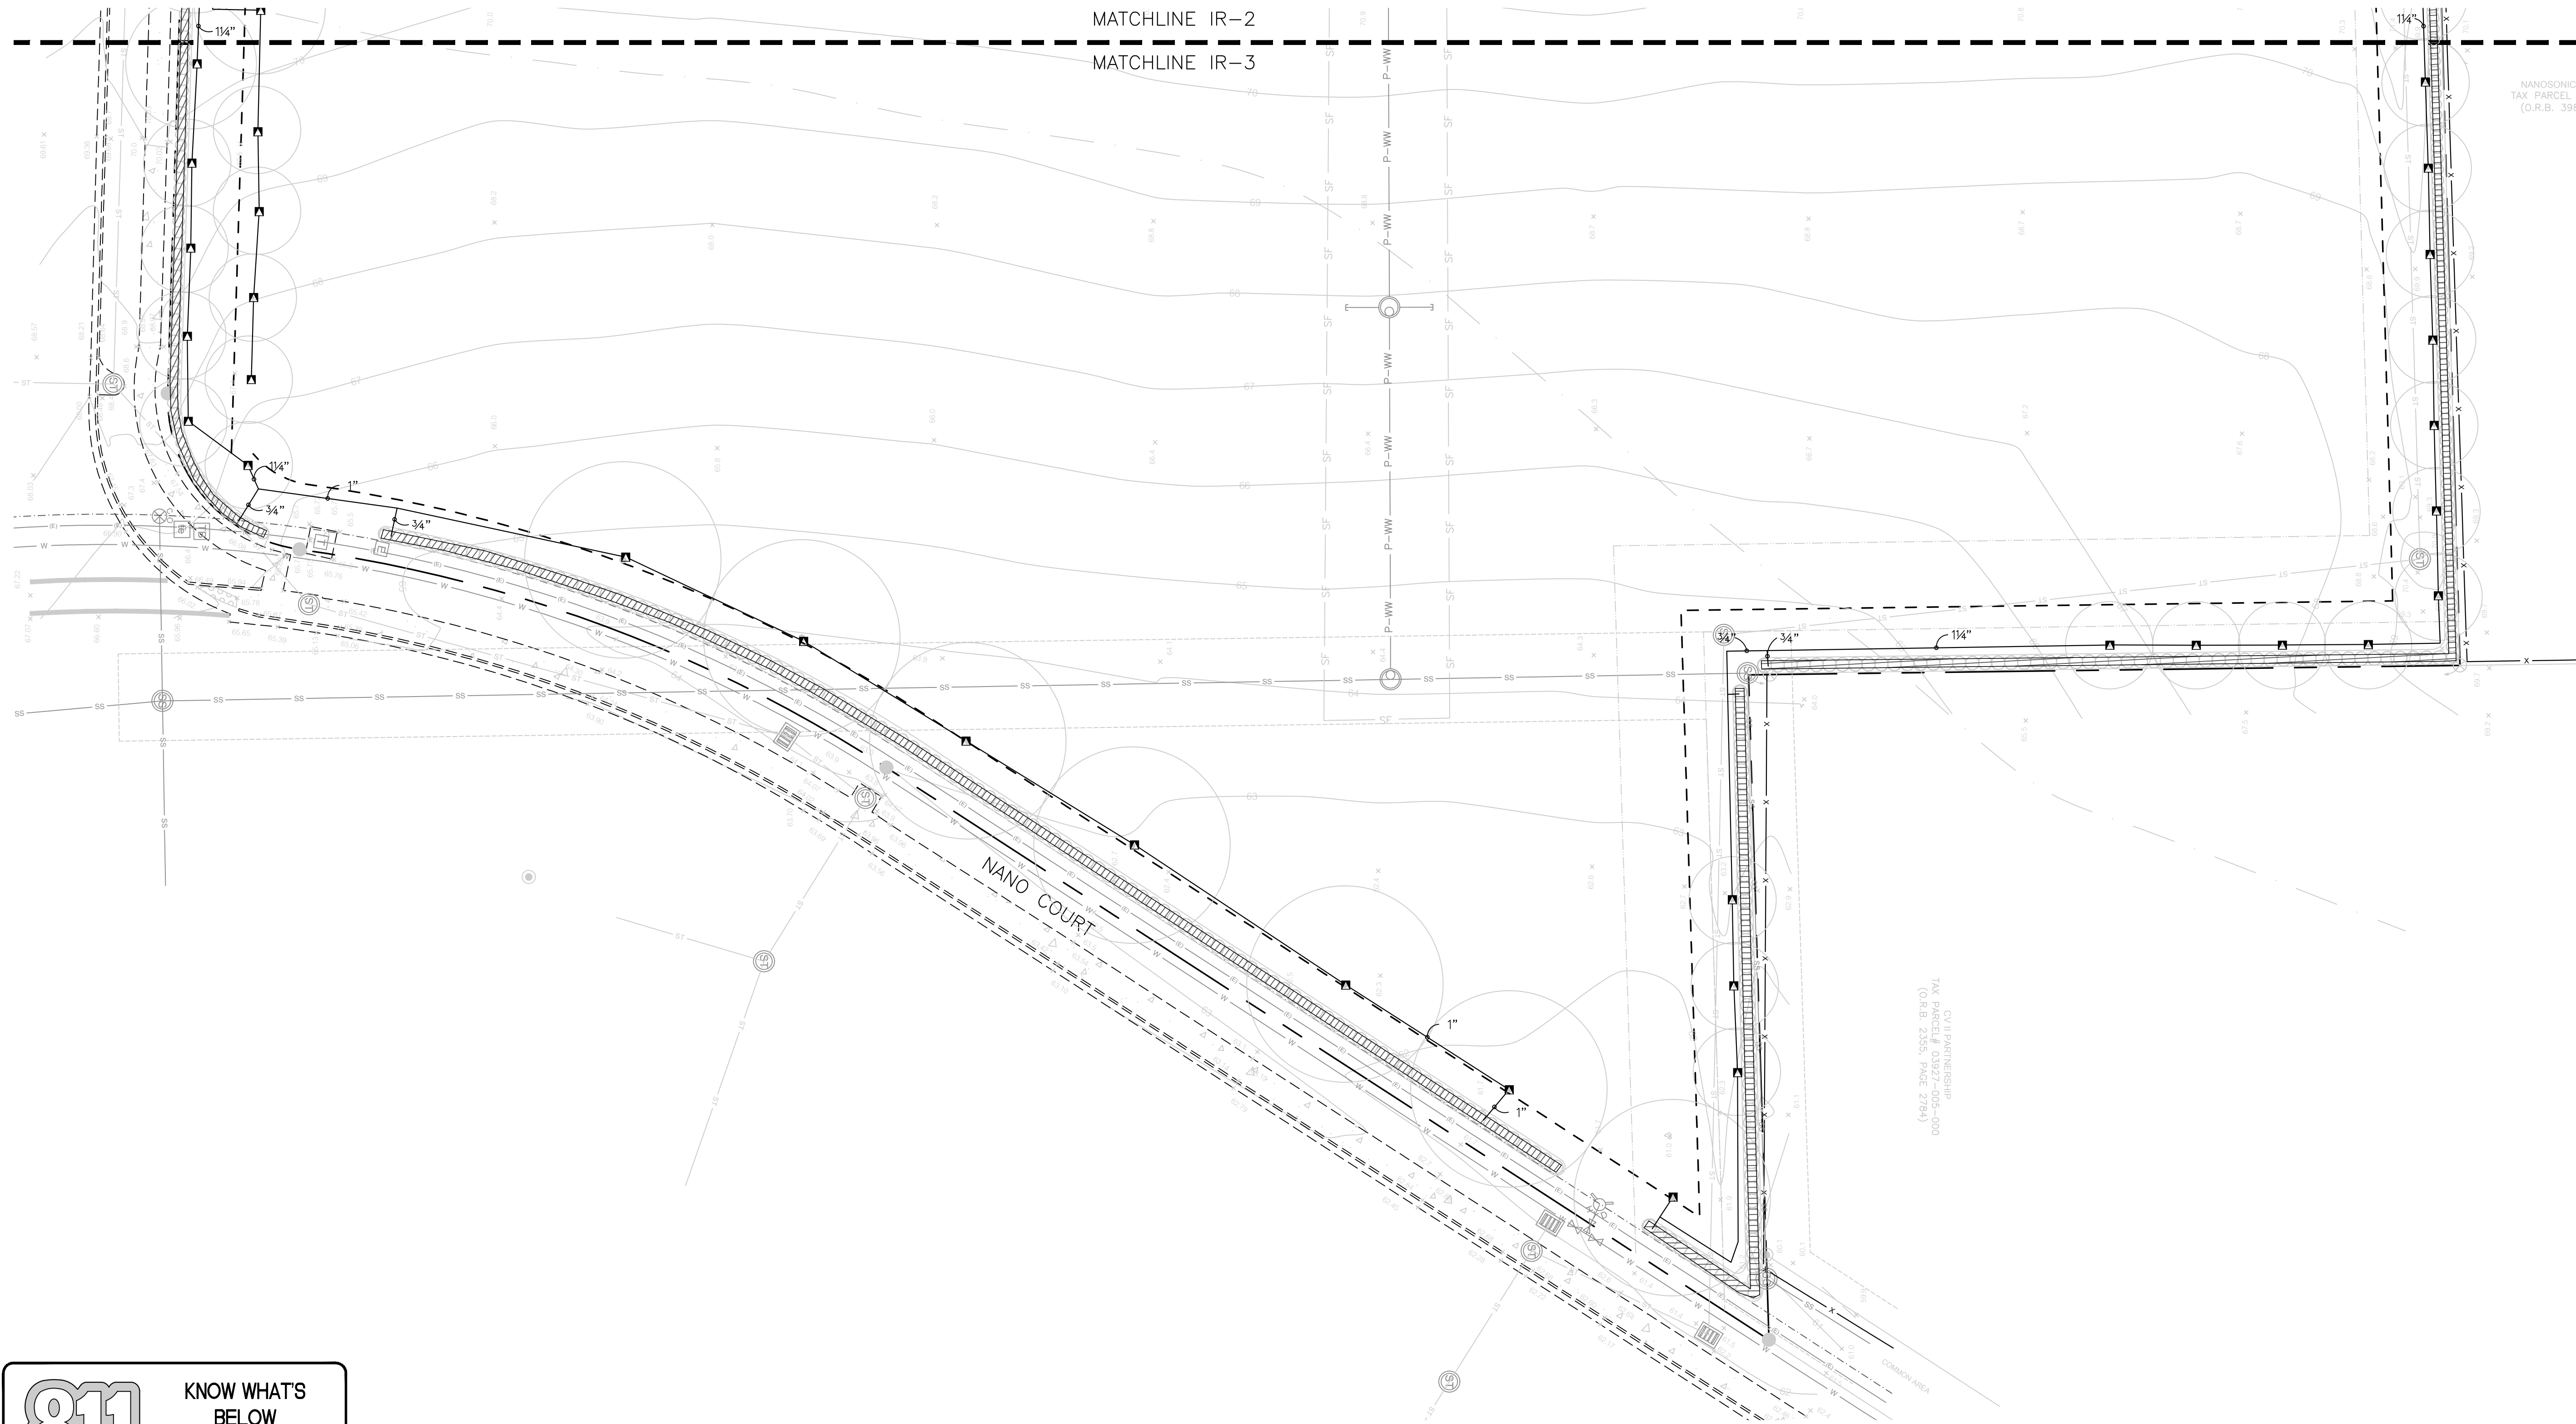



KNOW WHAT'S
BELOW
ALWAYS CALL 811
BEFORE YOU DIG
It's fast, it's free, it's the law.
Call 811 two business days
before digging

REVISIONS		CLIENT	CONSTRUCTION/BDU REVISIONS		SCALE	CH2M Professional Consultants	132 NW 78th Drive Gainesville, Florida 32607 (852) 331-1976 / (852) 331-2476 www.ch2m-hill.com est. 1988 LC28000564
DESIGNED BY C. TOLAR	CONCEPT DEVELOPMENT, INC.	10/31/16	CITY OF ALACHUA REVIEW	1"=20'	AS SHOWN ON THIS SHEET, ADJUST SCALES ACCORDINGLY.		
DESIGNED BY C. TOLAR	PROJECT: COPELAND PARK PHASE I	11/23/16	CITY OF ALACHUA REVIEW				
QUALITY CONTROL L. HALL	SHEET TITLE IRRIGATION PLAN	01/05/16	CITY OF ALACHUA REVIEW				
PROJECT NUMBER: 16-0366		02/03/17	CITY OF ALACHUA REVIEW				
SHEET NO.: IR-3							

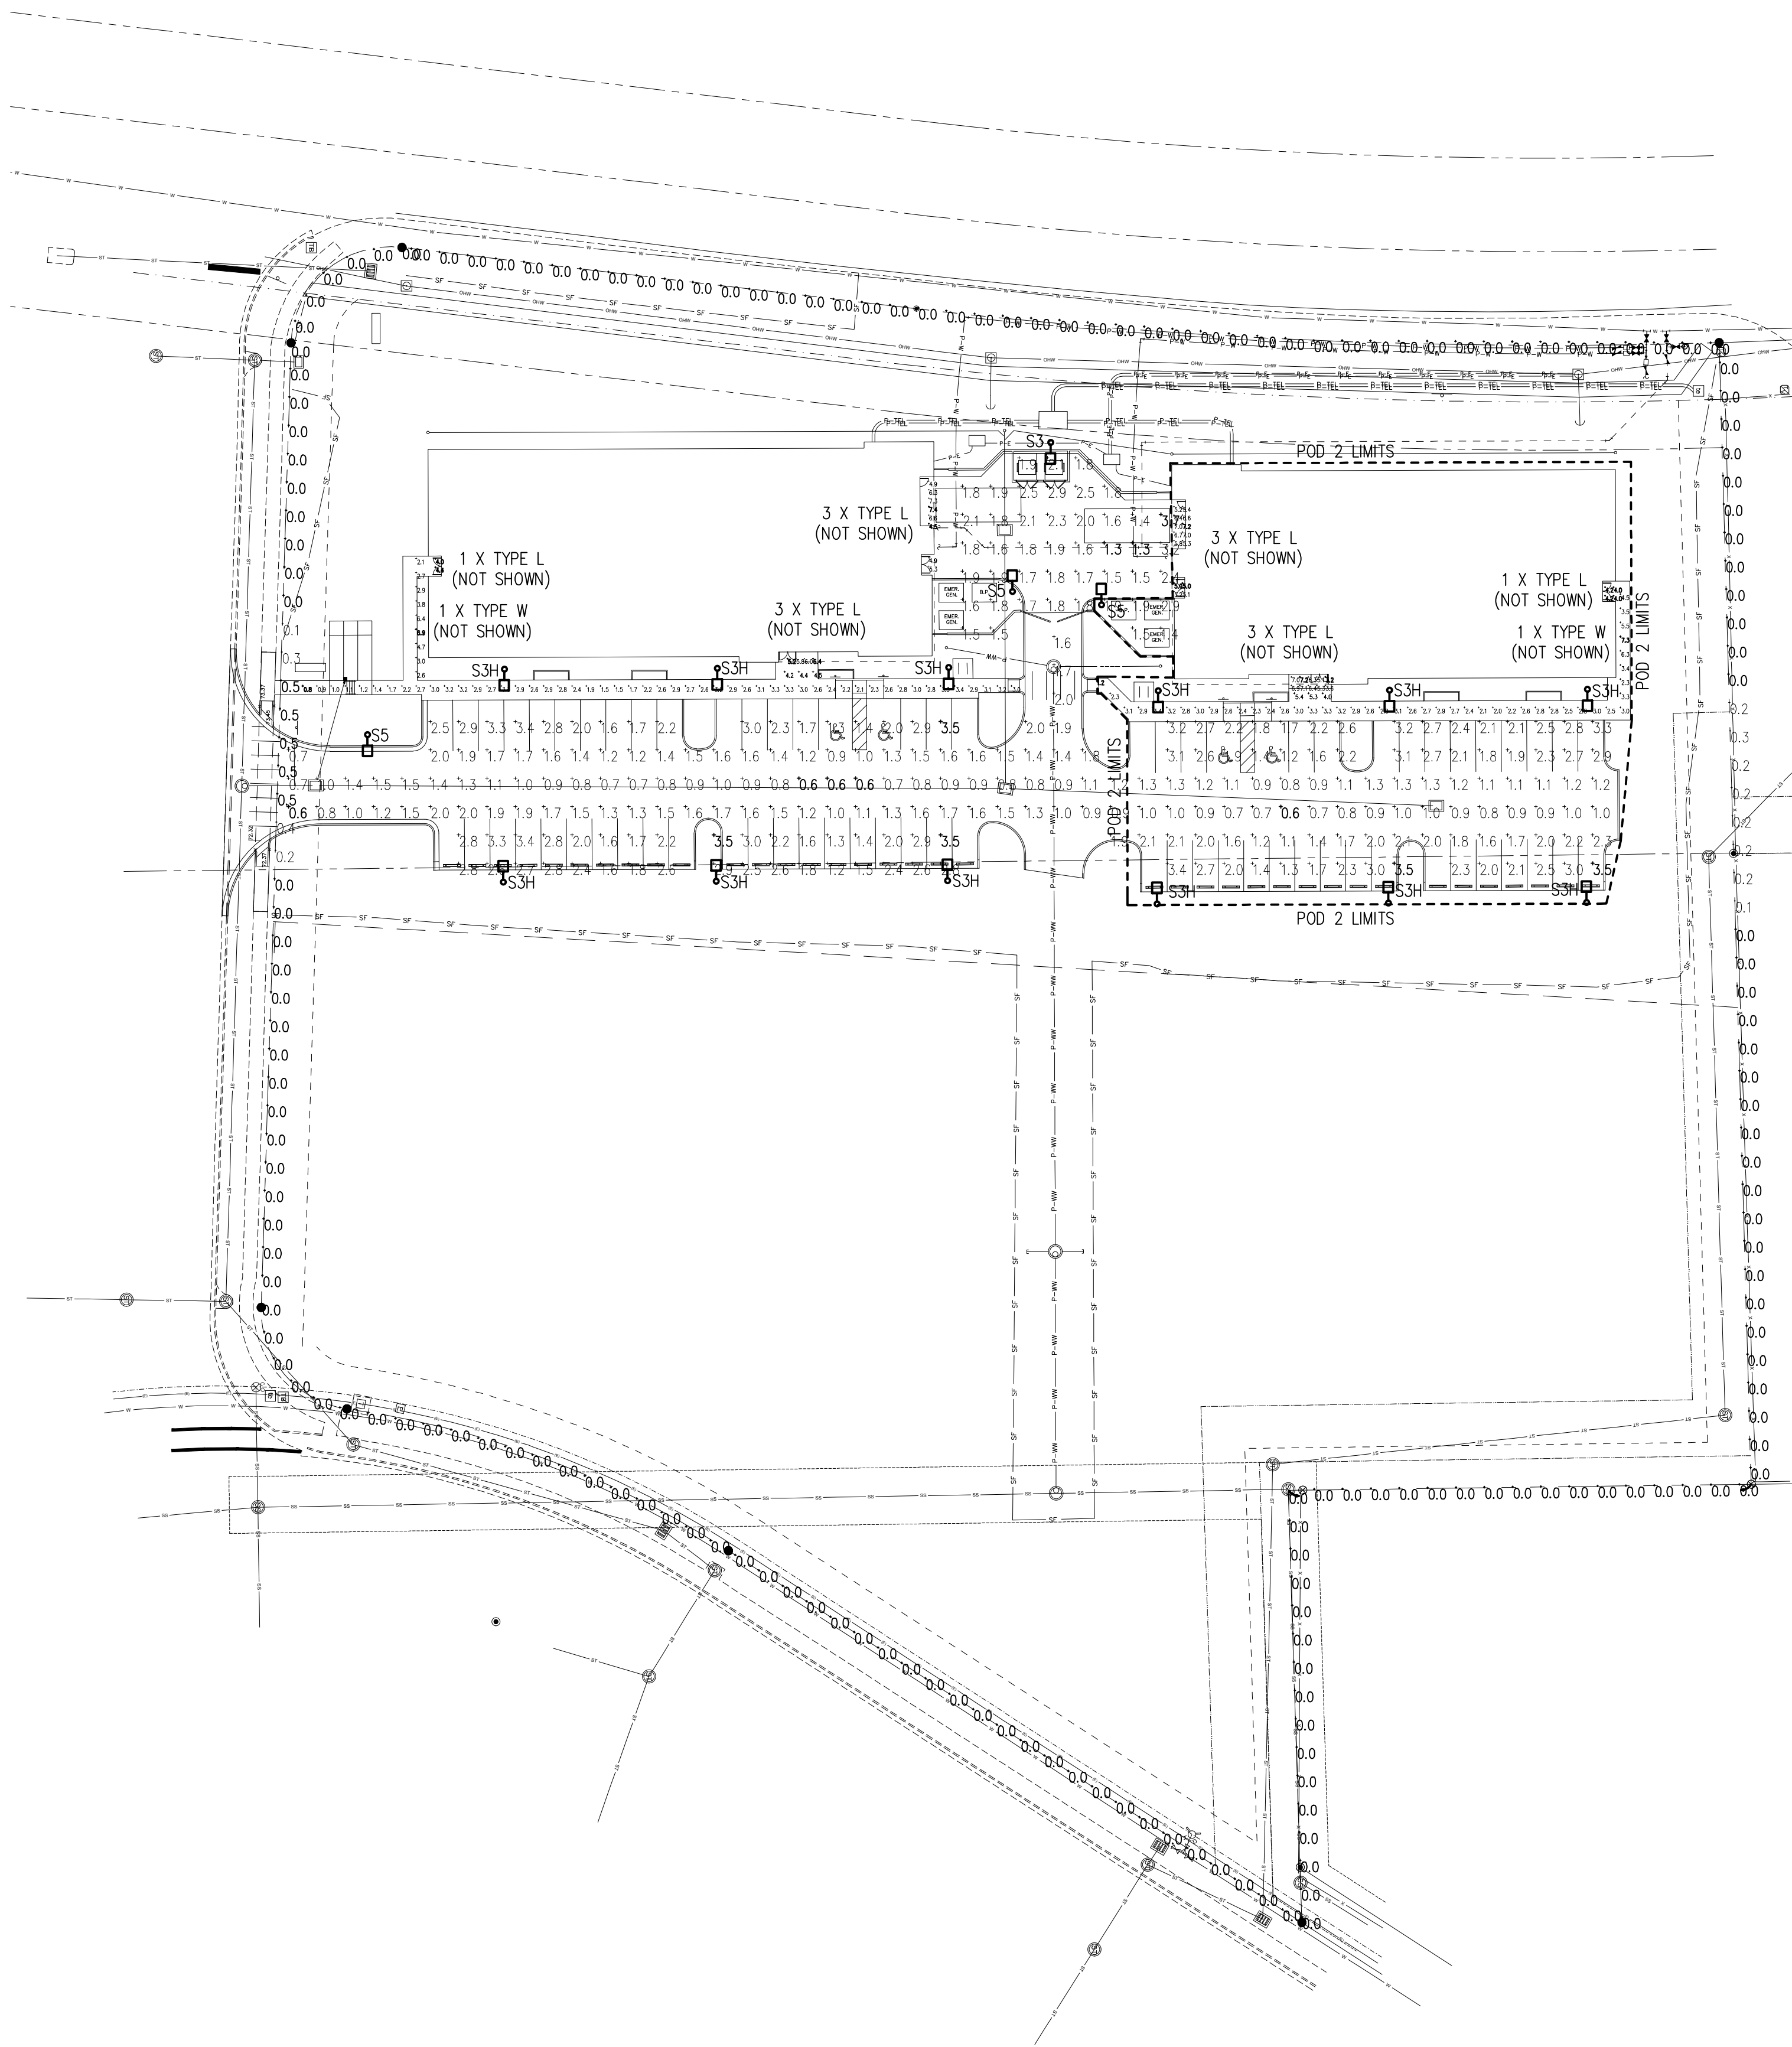


PHOTOMETRIC STATISTICS						
Descri tion	Sy bol	A g	Max	Min	Max/Min	A g/Min
LEFT FRONT ENTRY	+	5.9 fc	6.4 fc	5.2 fc	1.2:1	1.1:1
LEFT SERVICE ENTRY	+	5.9 fc	7.4 fc	4.5 fc	1.6:1	1.3:1
LEFT SIDE ENTRY	+	4.2 fc	4.4 fc	4.0 fc	1.1:1	1.1:1
LEFT SIDEWALK	+	2.8 fc	6.9 fc	0.8 fc	8.6:1	3.5:1
PARKING LOT	+	1.7 fc	3.5 fc	0.6 fc	5.8:1	2.8:1
PROPERTY LINE	+	0.0 fc	0.5 fc	0.0 fc	N / A	N / A
RIGHT FRONT ENTRY	+	5.8 fc	7.2 fc	3.2 fc	2.3:1	1.8:1
RIGHT FRONT WALK	+	3.1 fc	7.3 fc	1.2 fc	6.1:1	2.6:1
RIGHT SERVICE ENTRY	+	5.9 fc	7.2 fc	5.0 fc	1.4:1	1.2:1
RIGHT SIDE ENTRY	+	4.1 fc	4.2 fc	4.0 fc	1.1:1	1.0:1
SERVICE YARD	+	1.9 fc	3.7 fc	1.3 fc	2.8:1	1.5:1

LUMINAIRE SCHEDULE FOR PHOTOMETRICS											
Sy bol	Label	Qty	Man ifact urer	Catalog N umber	Descri tion	La	File	L ens	LLF	Watts	MH
	S5	3	COOPER	GLEON-AE-01-LED-E1-5MQ	GALLEON LED AREA AND ROADWAY LUMINAIRE (1) 70 CRI, 4000K, 1A LIGHTSQUARE WITH 16 LEDS AND TYPE V MEDIUM OPTICS		GLEON-AE-01-LED-E1-5MQ.ies	5644	0.81	56	15
	S3	1	COOPER	GLEON-AE-01-LED-E1-T3	GALLEON LED AREA AND ROADWAY LUMINAIRE (1) 70 CRI, 4000K, 1A LIGHTSQUARE WITH 16 LEDS AND TYPE III OPTICS		GLEON-AE-01-LED-E1-T3.ies	5374	0.81	56	15
	S3H	12	COOPER	GLEON-AE-02-LED-E1-T3-700	GALLEON LED AREA AND ROADWAY LUMINAIRE (2) 70 CRI, 4000K, 700 A LIGHTSQUARES WITH 16 LEDS EACH AND TYPE III OPTICS		GLEON-AE-02-LED-E1-T3-700.ies	7676	0.81	72	15
	L	14	KIRLIN	LRR-07462-WFL	1 WHITE CIRCUIT BOARD WITH 4 LEDS, SPUN WHITE PAINTED METAL REFLECTOR, CLEAR PRISMATIC FLAT GLASS LENS	FOUR WHITE LEDs	LRR-07462-WFL.IES	1187	0.81	21	CEIL RECESS 9.5
	W	2	H.E. WILLIAMS	VWPH-L30-740-T3 CGL-OPT-EDD-UNV	VOLTAIRE HORIZONTAL ARCHITECTURAL WALL PACK WITH TYPE III MOLDED REFRACTIVE CLEAR ACRYLIC LED LENS AND CLEAR GLASS LENS.	(4) LUXEON M 4000K LEDS	VWPH-L30-740-T3-CLR-OPT-EDD-UNV.IES	3106	0.81	88	9


GENERAL NOTES

- HIGHLIGHTED POINTS REPRESENT MAXIMUM/MINIMUM VALUE FOR EACH AREA.
- FIXTURES WILL BE CONTROLLED WITH PHOTOCELL AND OPERATE DUSK-TO-DAWN.
- POLE LIGHT LOCATIONS HAVE BEEN COORDINATED WITH EXISTING AND PROPOSED TREES.

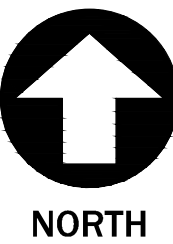

SITE PHOTOMETRIC PLAN

SCALE: 1" = 40'

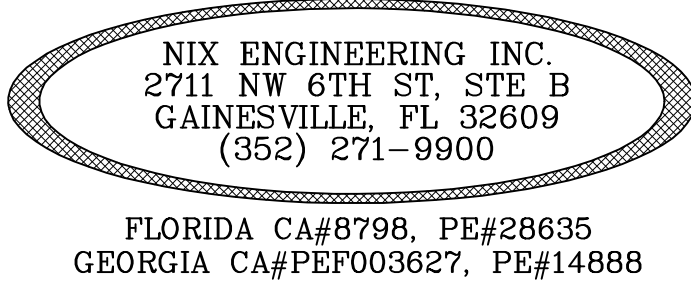

FLORIDA CA#8798, PE#28635
GEORGIA CA#PEF003627, PE#14888

NIX ENGINEERING, INC.
CONSULTING ENGINEERS
2711 NW 6TH ST, STE B
GAINESVILLE, FL

COPELAND PARK
SITE PHOTOMETRIC PLAN
NW 6TH PL
GAINESVILLE, FL

Drawing Number

E-1

Project Number	1699
Date	2/6/17
Designed By	KWH
Checked By	R/N

Rev	Date	Description
